


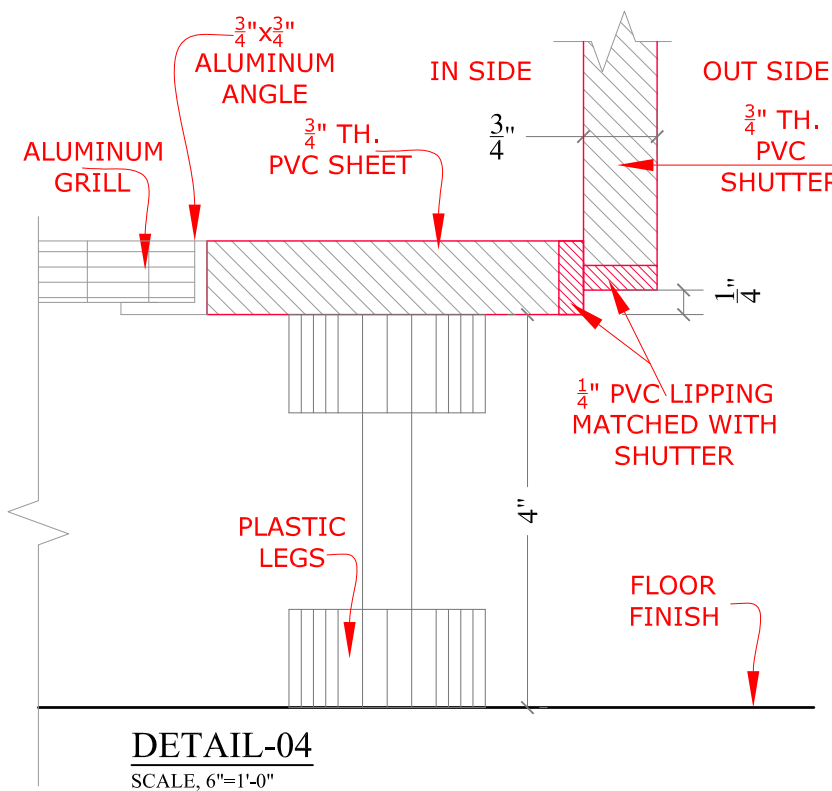
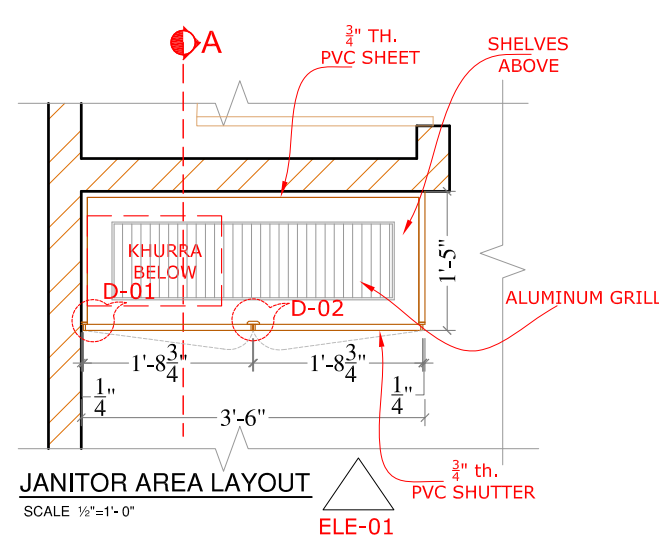
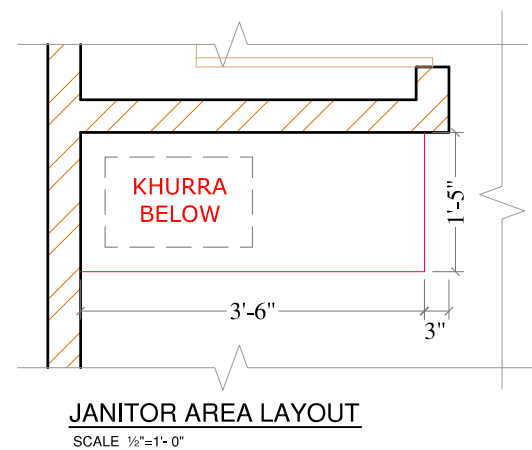
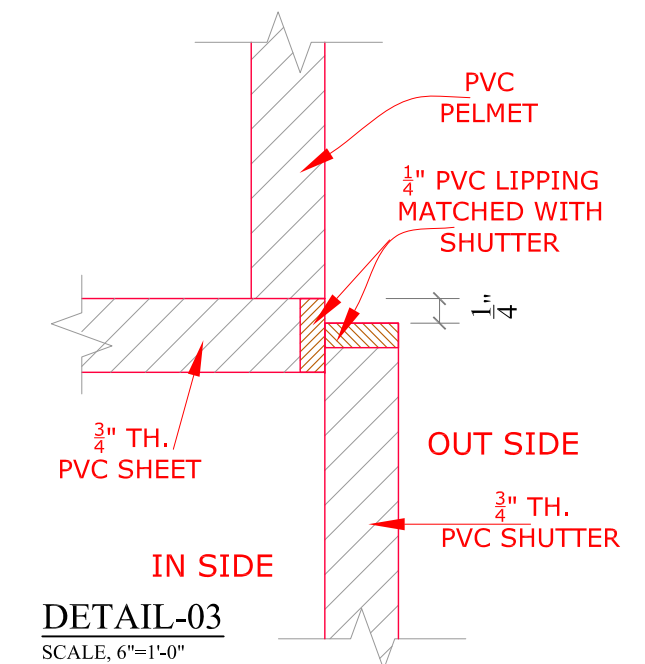
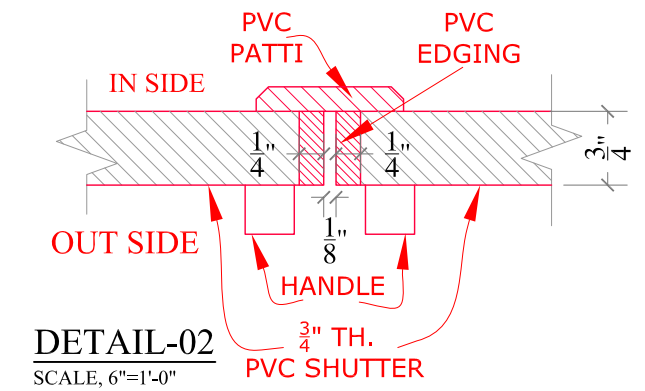
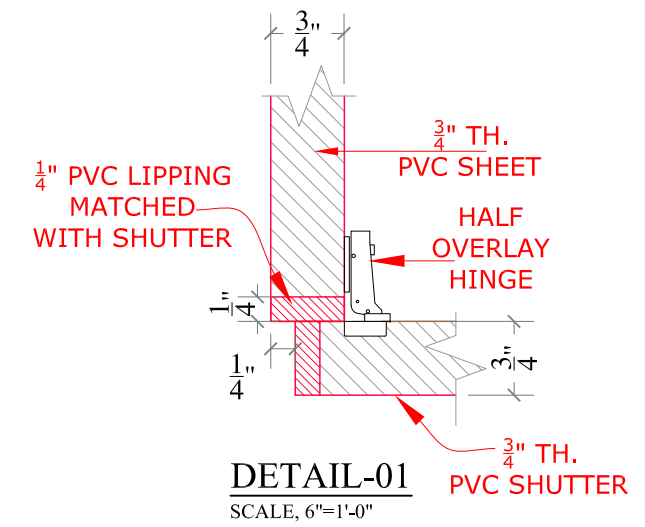
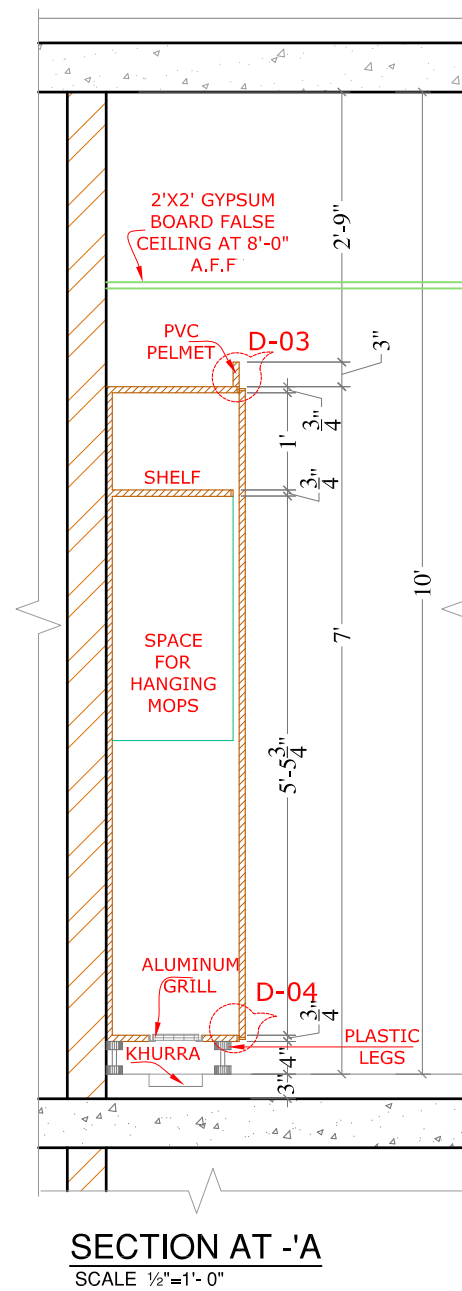


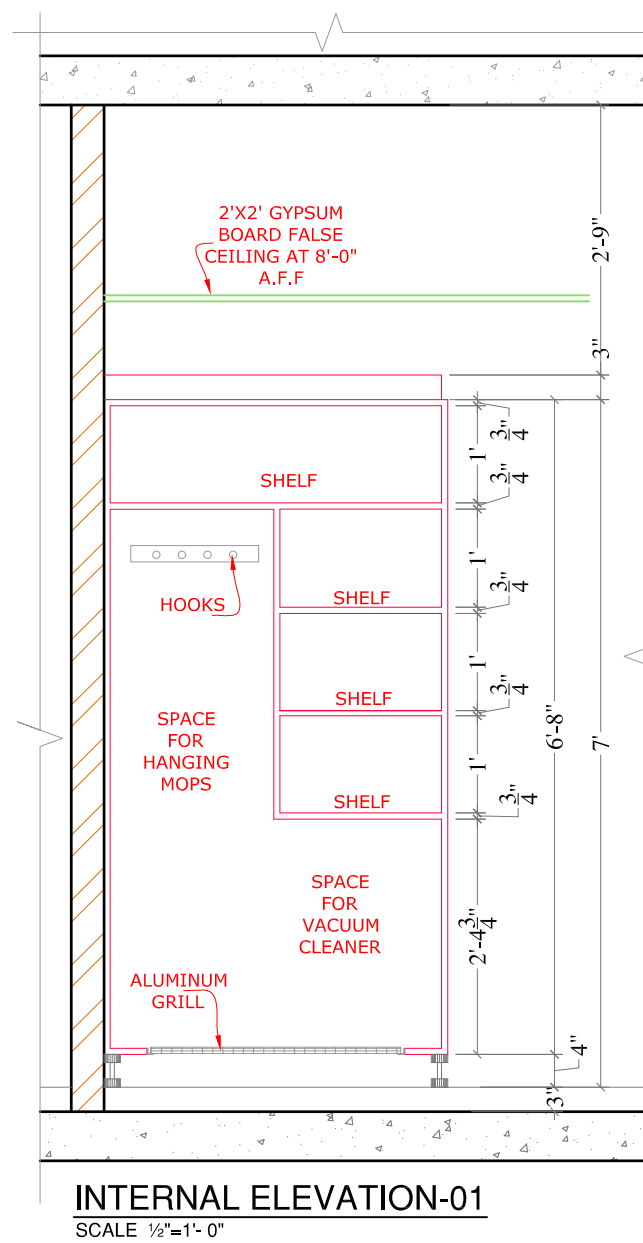


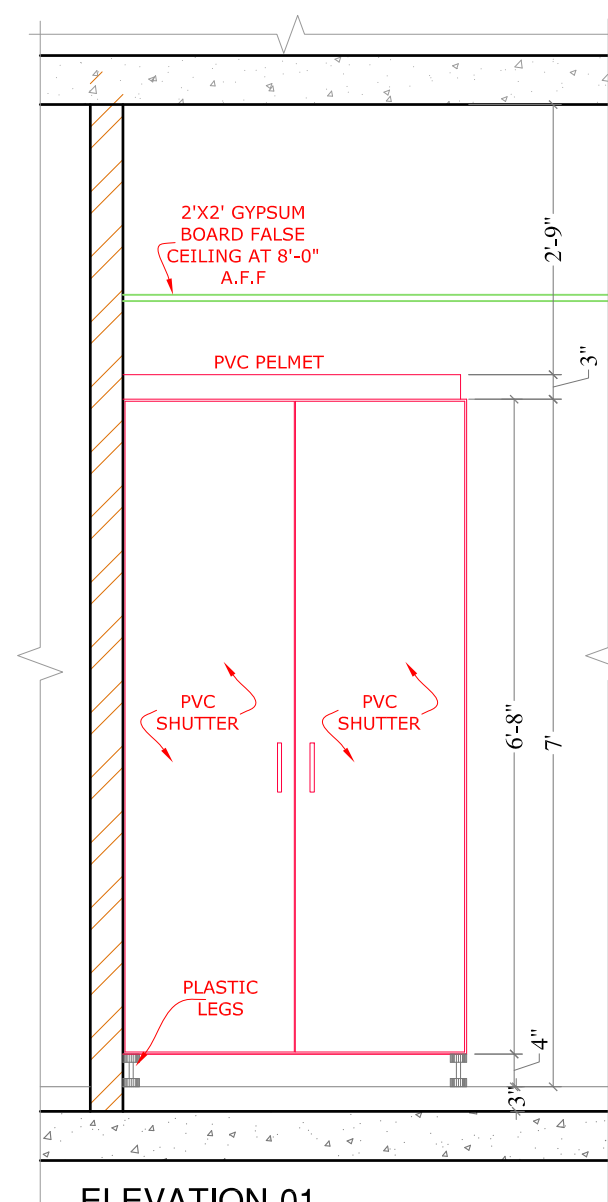



REV.	DATE	DESCRIPTION	BY	CHK	APP
CLIENT					
SECURITIES AND EXCHANGE COMMISSION OF PAKISTAN					
PROJECT					
CRO INTERIOR RENOVATION 3RD & 4TH FLOOR LAHORE					
DESIGN PHASE					
TENDER DRAWINGS					
TITLE					
JANITOR CLOSET DETAIL					
DESIGN	DRAWN		SCALE		
SHAZIA QURESHI	USMAN HAIDER		AS SHOWN		
CHECKED	APPROVED		DATE		
SHAZIA QURESHI	SHAZIA QURESHI		15 June, 2020		
NORTH	JOB No.		A- 2125		
	DRG. No.		A-56		
CONSULTANT:					
SOHAIL A. KHAN ASSOCIATES					
Architecture and Designing					
House #159, Street 4, Race Course Road, Rawalpindi					
Tel: 5174329 - 5174098; Fax: 5125075					
Email: mail@saka.net.pk					
					

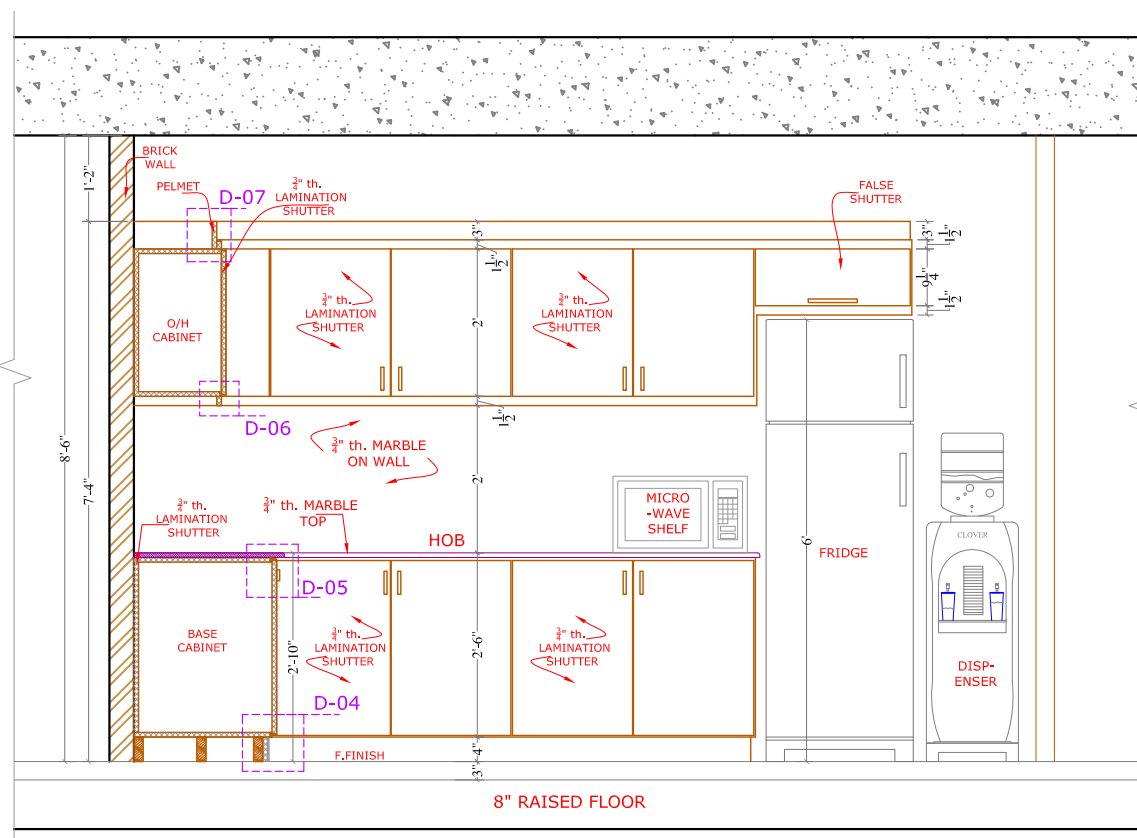


SECTION AT-A'
SCALE, $\frac{1}{2}"=1'-0"$

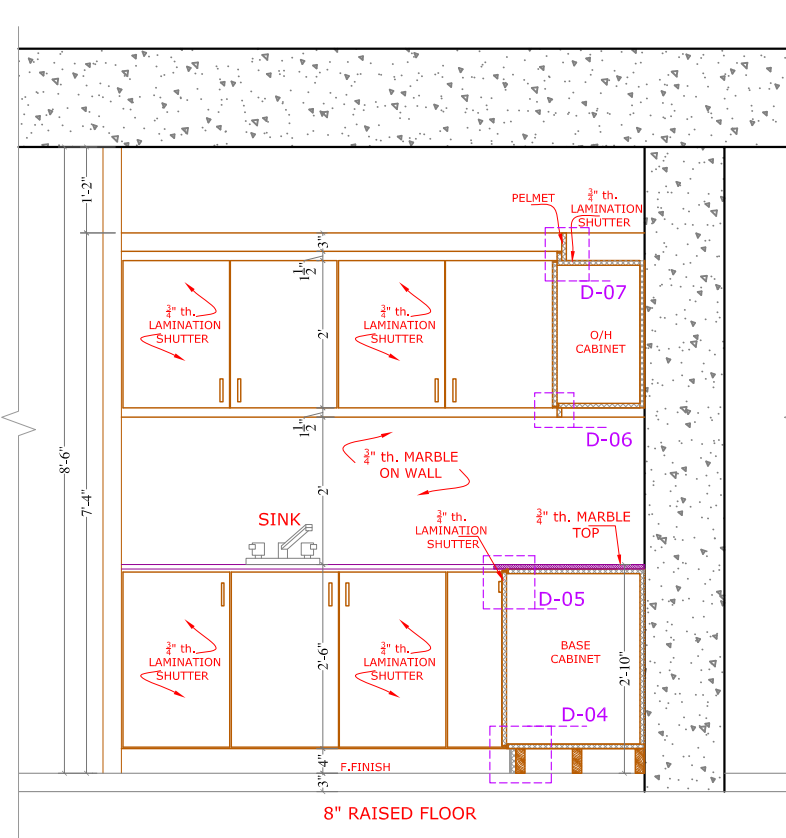


SECTION AT-B'
SCALE, $\frac{3}{8}"=1'-0"$

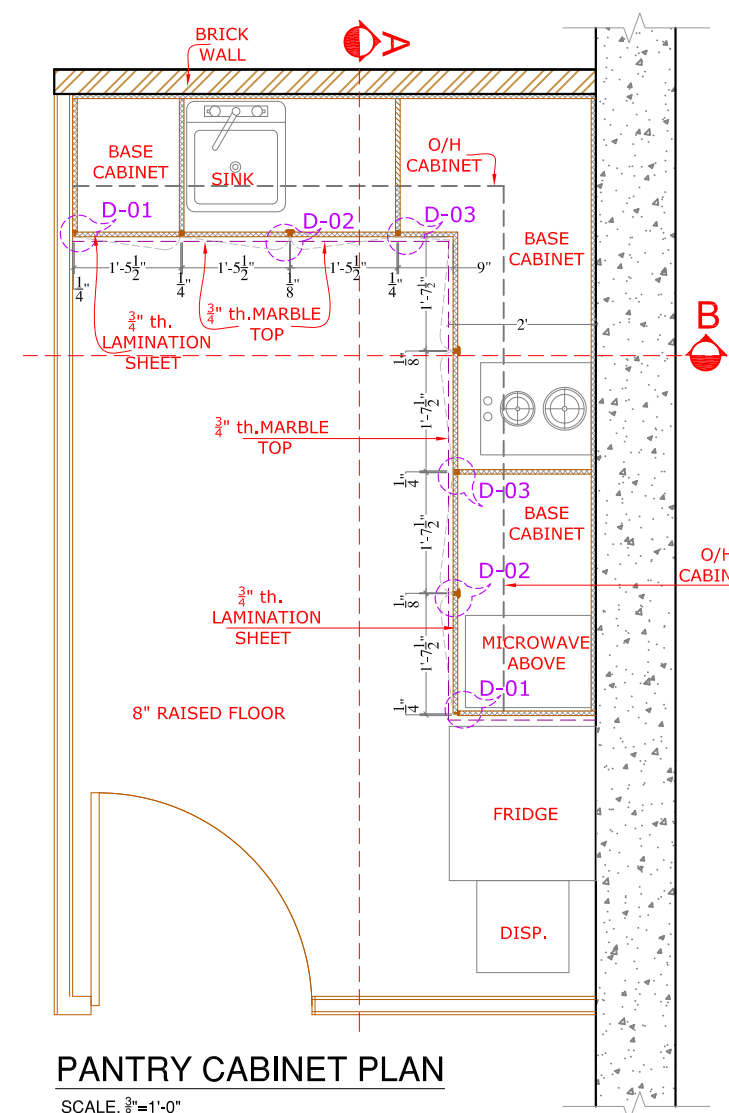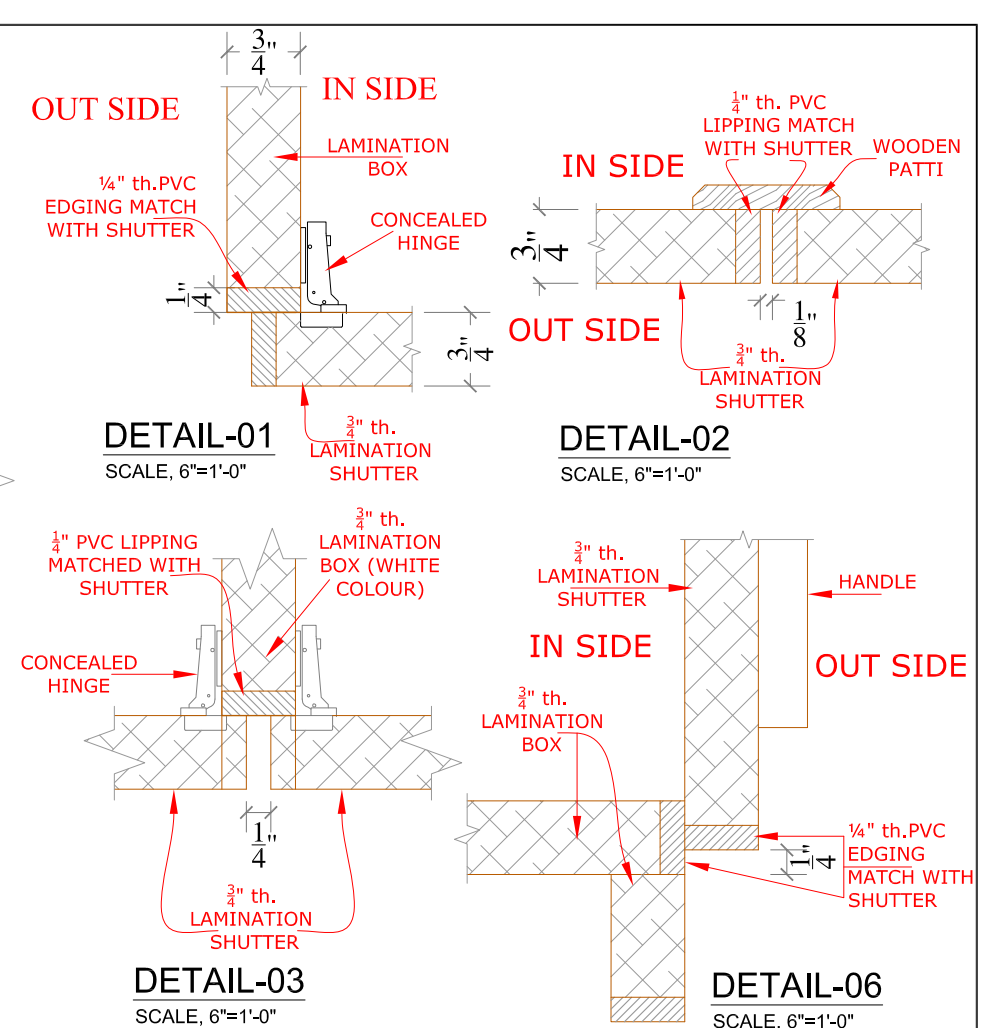


PANTRY CABINET PLAN
SCALE, $\frac{3}{8}"=1'-0"$

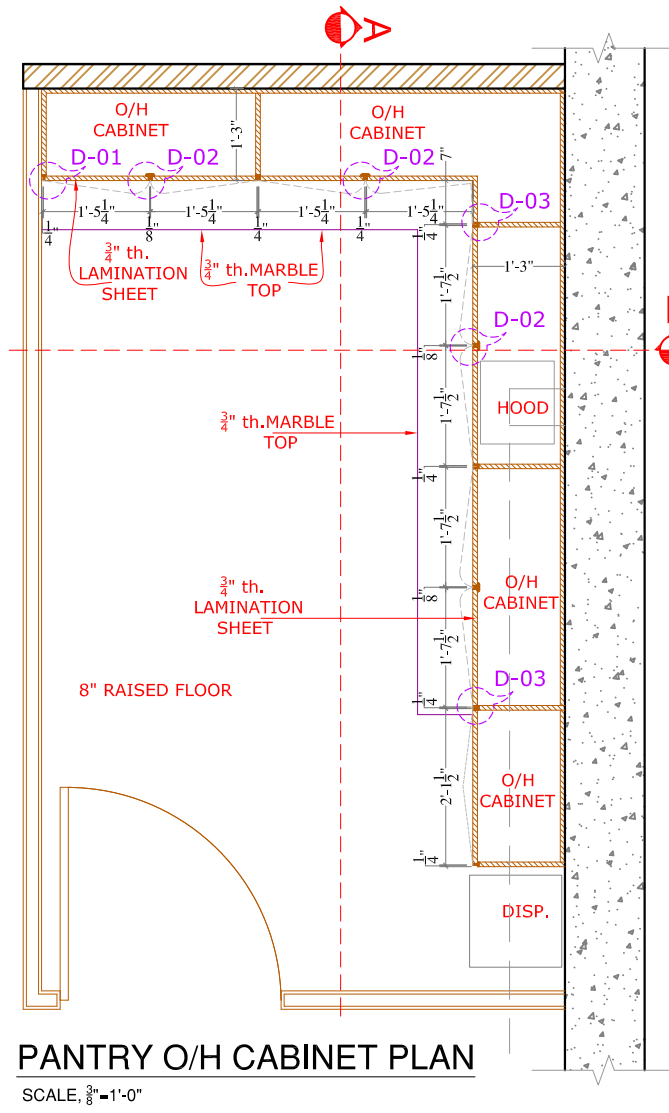

PANTRY O/H CABINET PLAN
SCALE, $\frac{3}{8}"=1'-0"$

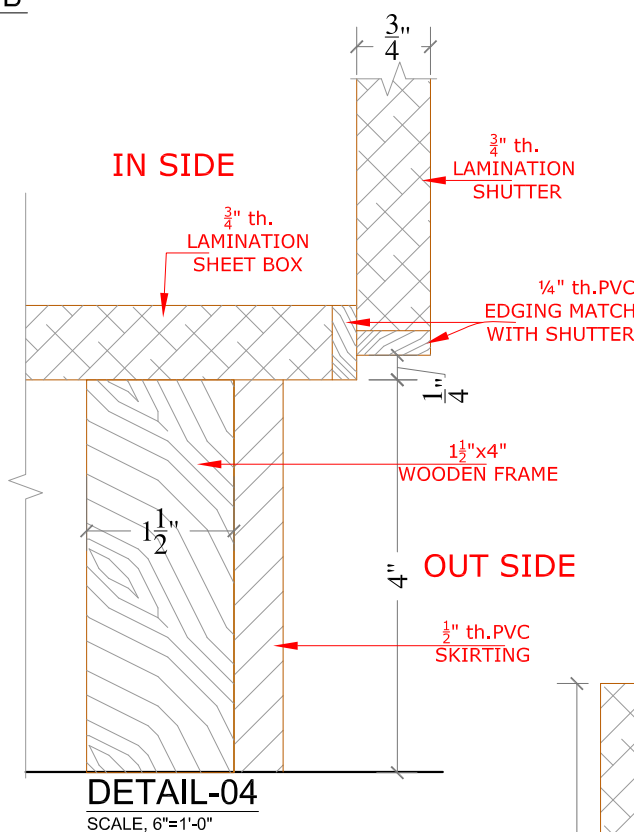


DETAIL-04
SCALE, 6"=1'-0"

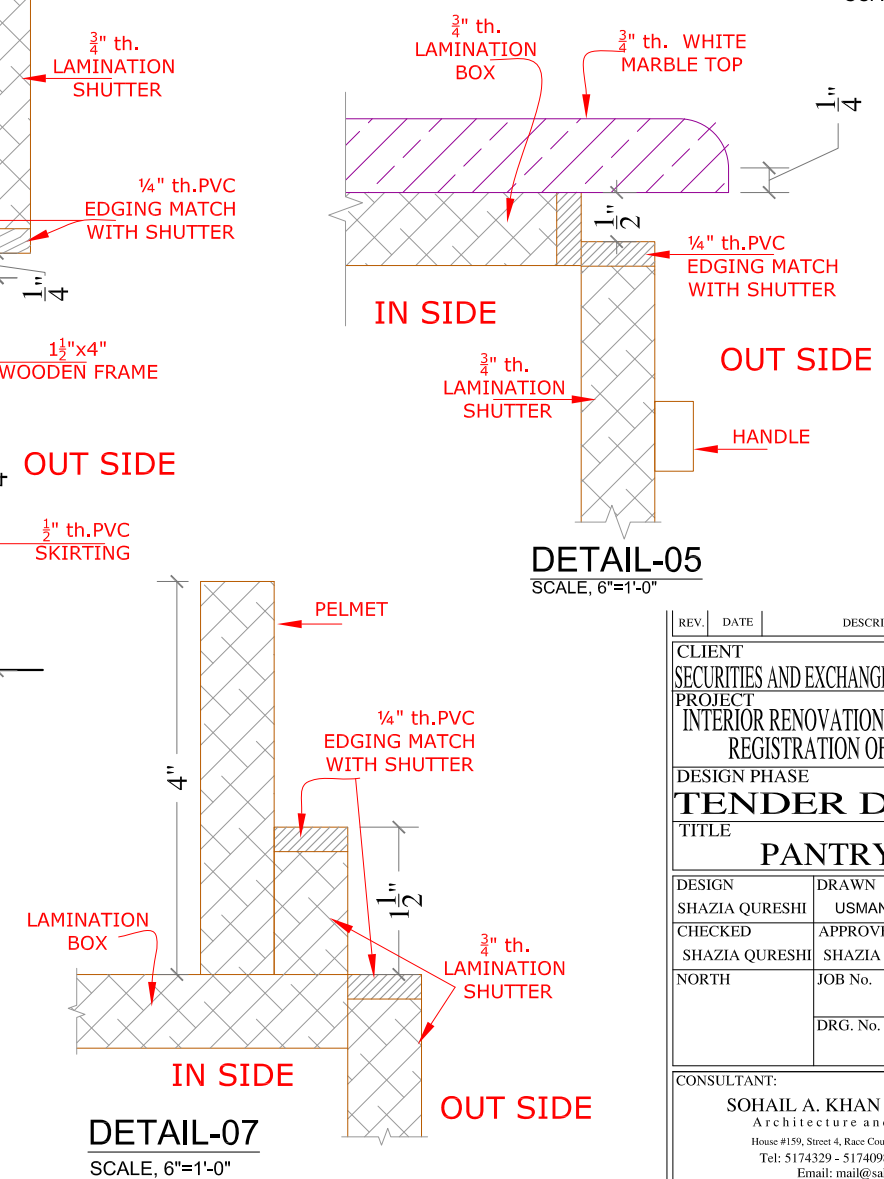

DETAIL-07
SCALE, 6"=1'-0"

REV.	DATE	DESCRIPTION	BY	CHKD	APP
CLIENT					
SECURITIES AND EXCHANGE COMMISSION OF PAKISTAN					
PROJECT					
INTERIOR RENOVATION 4TH FLOOR COMPANIES					
REGISTRATION OFFICE AT KARACHI					
DESIGN PHASE					
TENDER DRAWINGS					
TITLE					
PANTRY DETAIL					
DESIGN	DRAWN		SCALE		
SHAZIA QURESHI	USMAN HAIDER		AS SHOWN		
CHECKED	APPROVED		DATE		
SHAZIA QURESHI	SHAZIA QURESHI		15 June, 2020		
NORTH	JOB No.				
	A- 2125				
	DRG. No.				
	A-57				
CONSULTANT:					
SOHAIL A. KHAN ASSOCIATES					
Architecture and Designing					
House #159, Street 4, Race Course Road, Rawalpindi					
Tel: 5174329 - 5174098; Fax: 5125075					
Email: mail@saka.net.pk					
					




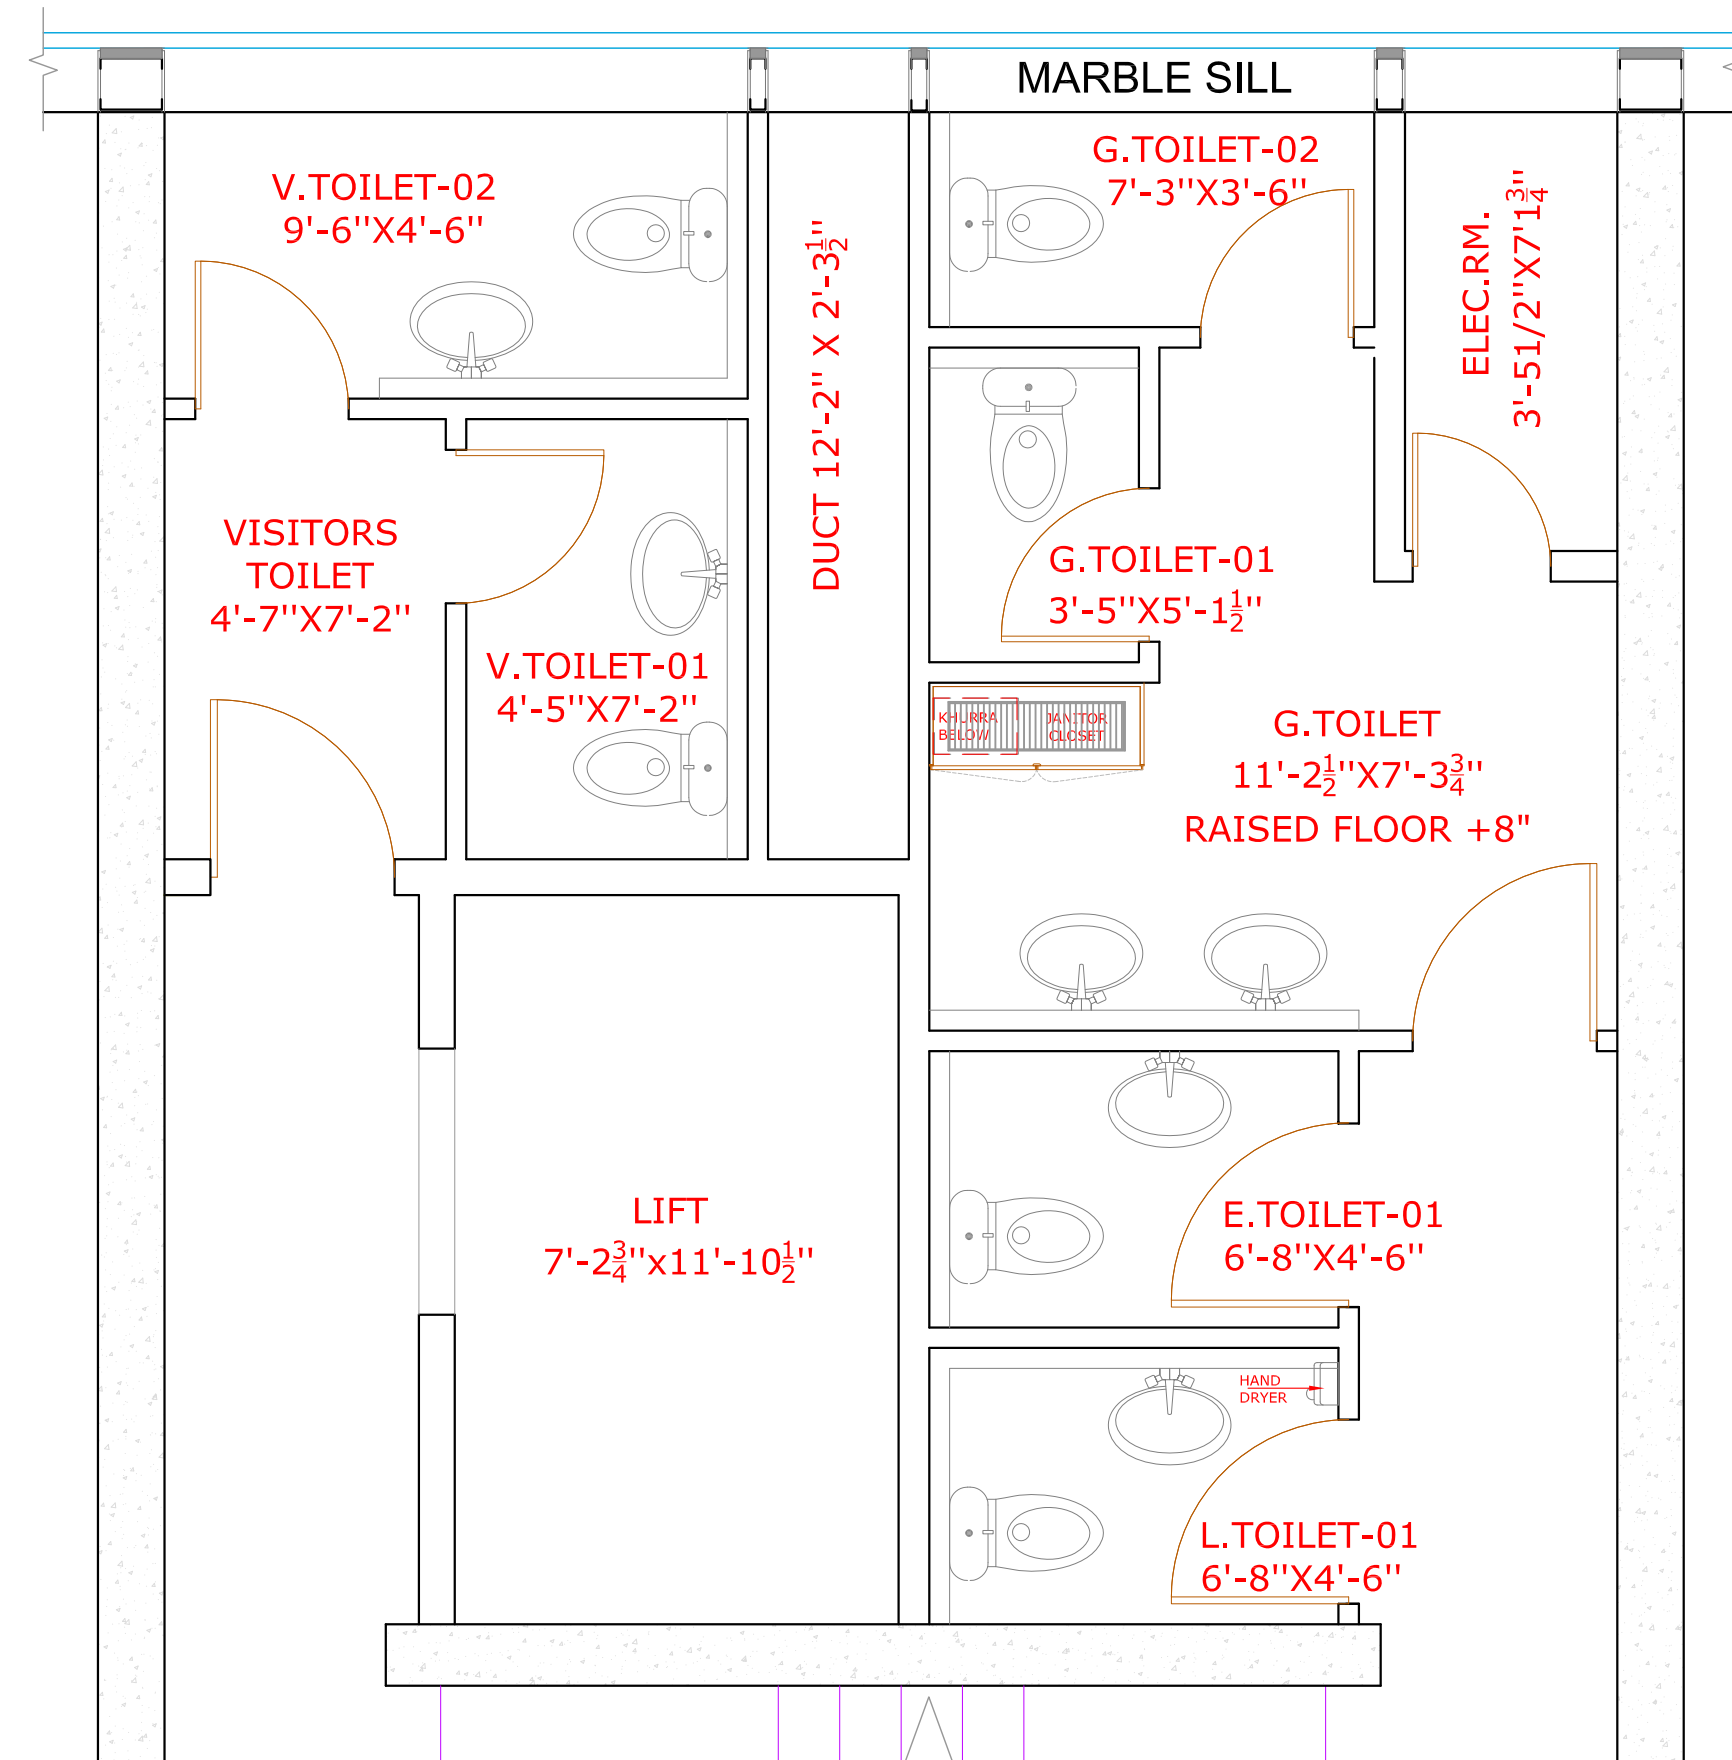


BATH LAYOUT PLAN





SCALE, $\frac{3}{32}$ "=1'-0"

REV.	DATE	DESCRIPTION		BY	CHD	APP
CLIENT SECURITIES AND EXCHANGE COMMISSION OF PAKISTAN PROJECT						
KARCHI OFFICE						
DESIGN PHASE						
TENDER DRAWINGS						
TITLE BATH DETAIL						
DESIGN SHAZIA QURESHI		DRAWN USMAN HAIDER		SCALE AS SHOWN		
CHECKED SHAZIA QURESHI		APPROVED SHAZIA QURESHI		DATE 30 May,2020		
NORTH		JOB No. A- 2125				
		DRG. No. A-58				
CONSULTANT: SOHAIL A. KHAN ASSOCIATES Architecture and Designing House #159, Street 4, Race Course Road, Rawalpindi Tel: 5174329 - 5174098; Fax: 5125075 Email: mail@saka.net.pk						
						




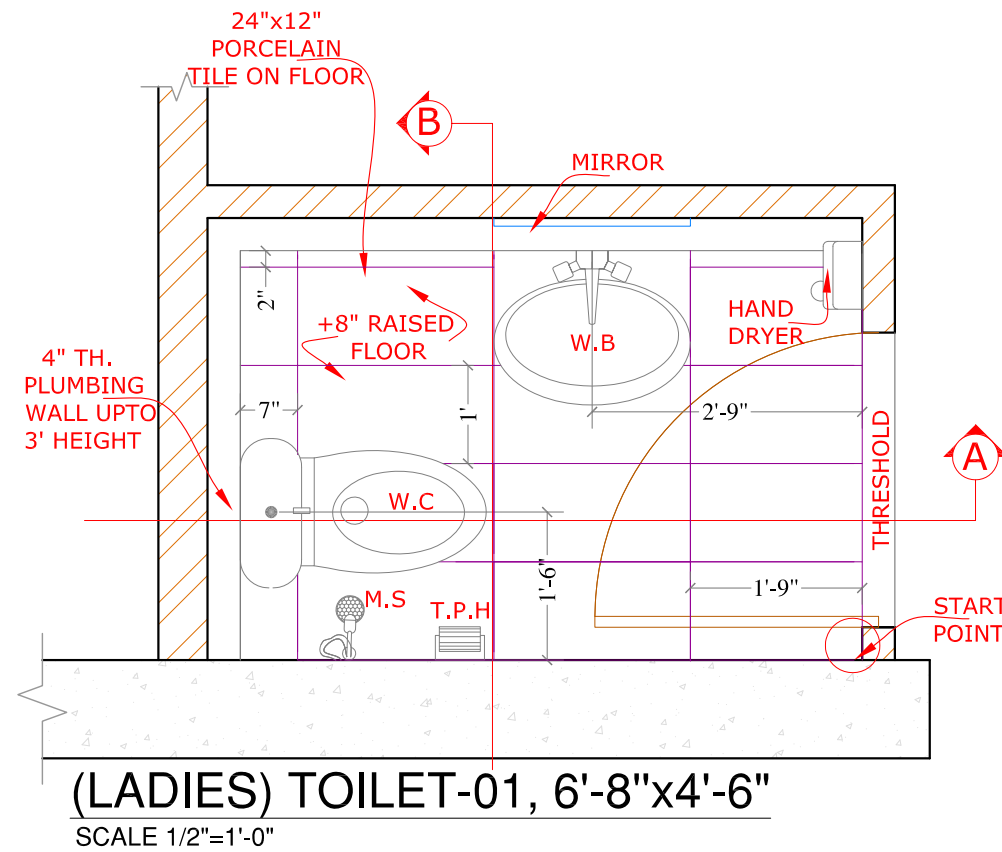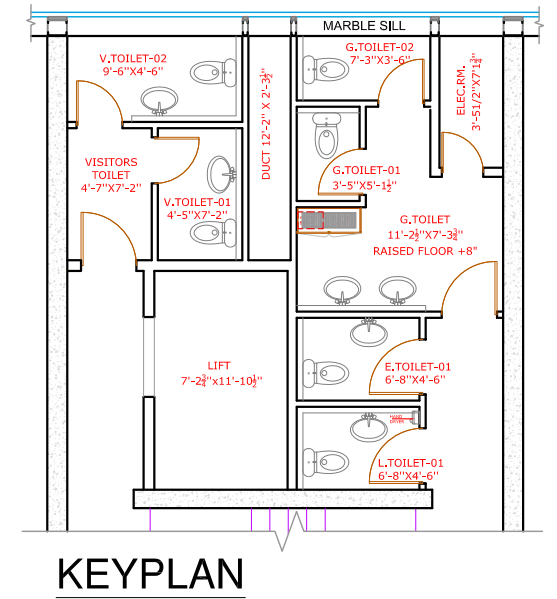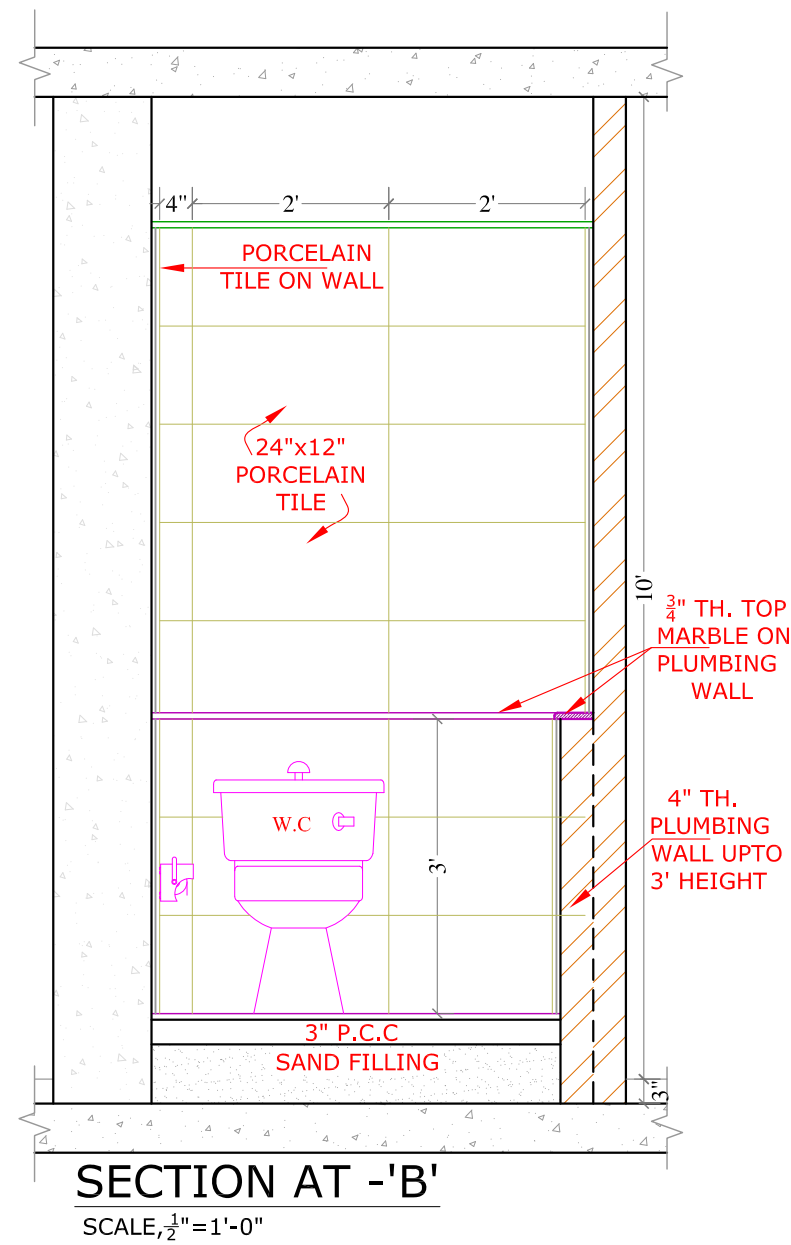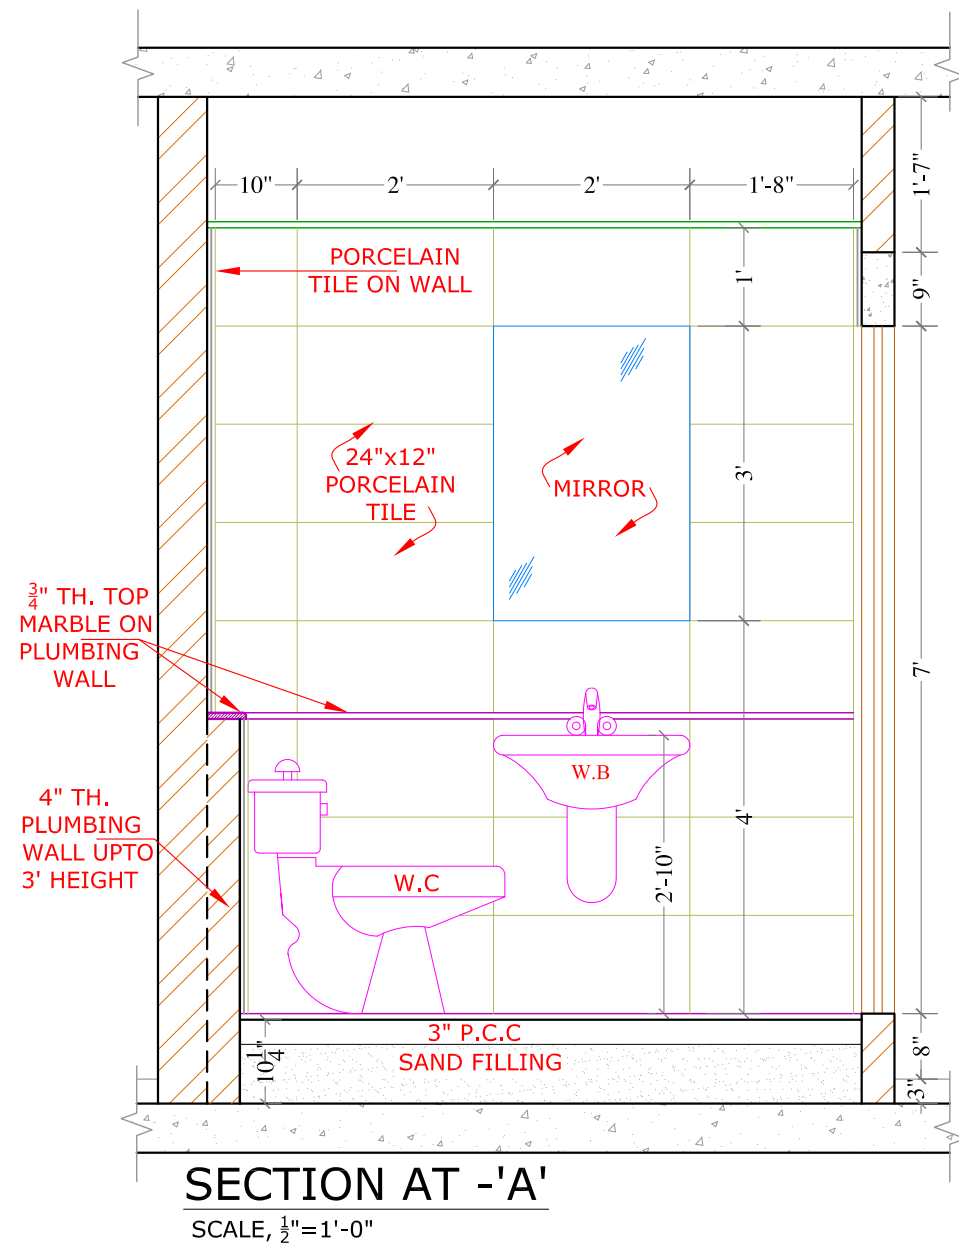


REV.	DATE	DESCRIPTION	BY	CHD	APP
CLIENT					
SECURITIES AND EXCHANGE COMMISSION OF PAKISTAN					
PROJECT					
KARCHI OFFICE					
DESIGN PHASE					
TENDER DRAWINGS					
TITLE					
BATH DETAIL					
DESIGN	SHAZIA QURESHI	DRAWN	USMAN HAIDER	SCALE	AS SHOWN
CHECKED	SHAZIA QURESHI	APPROVED	SHAZIA QURESHI	DATE	30 May,2020
NORTH	JOB No. A- 2125				
	DRG. No. A-59				
CONSULTANT:					
SOHAIL A. KHAN ASSOCIATES					
Architecture and Designing					
House #159, Street-4, Race Course Road, Rawalpindi					
Tel: 5174329 - 5174098; Fax: 5125075					
Email: mail@saka.net.pk					
					

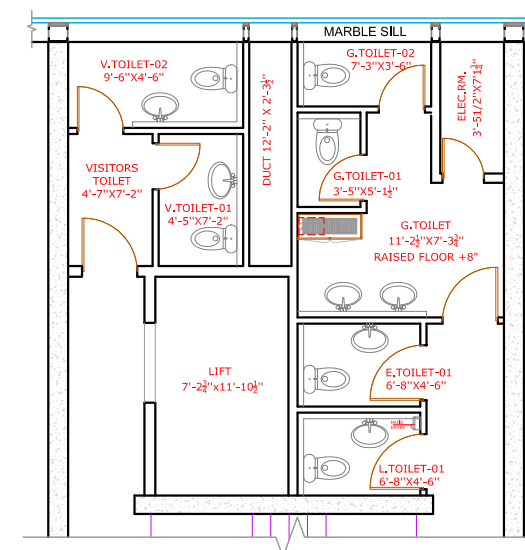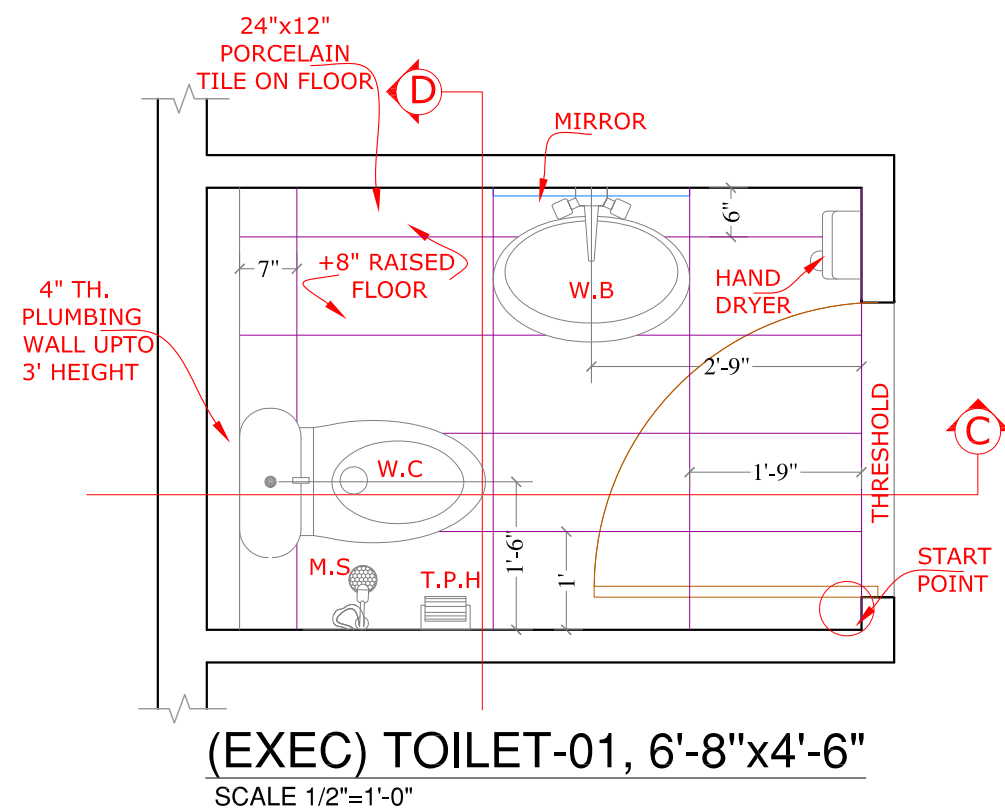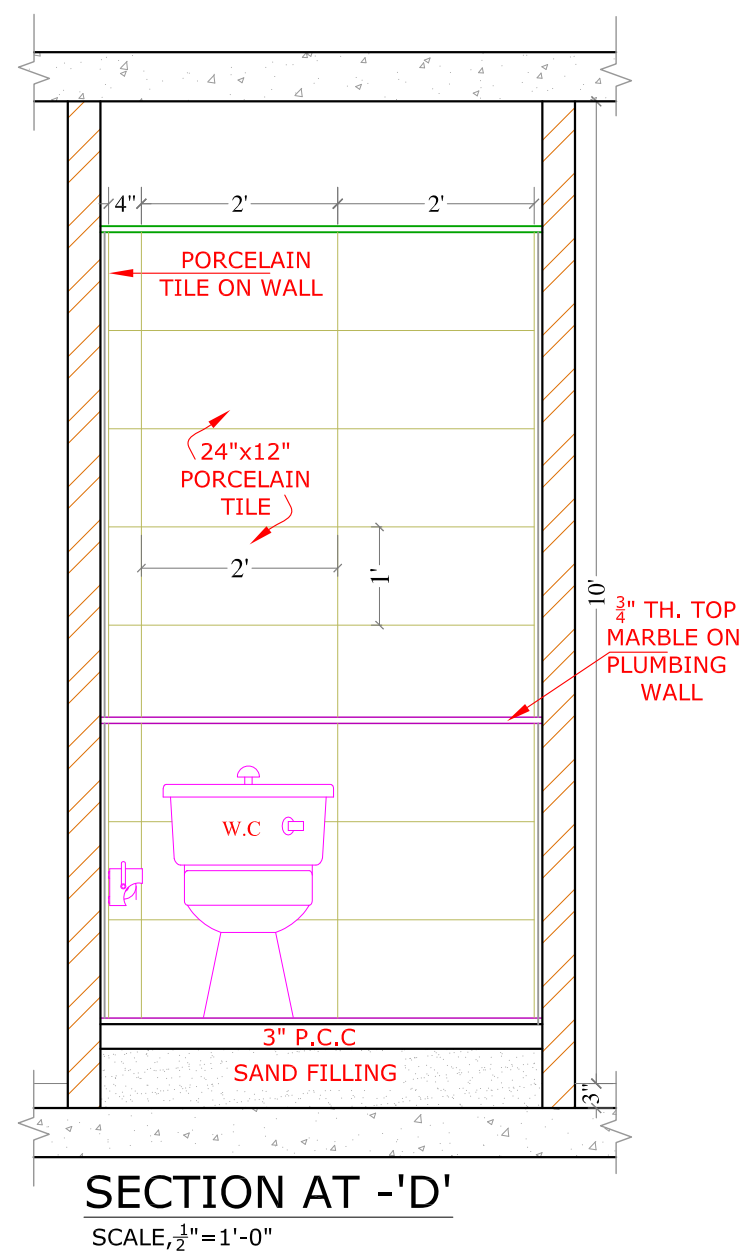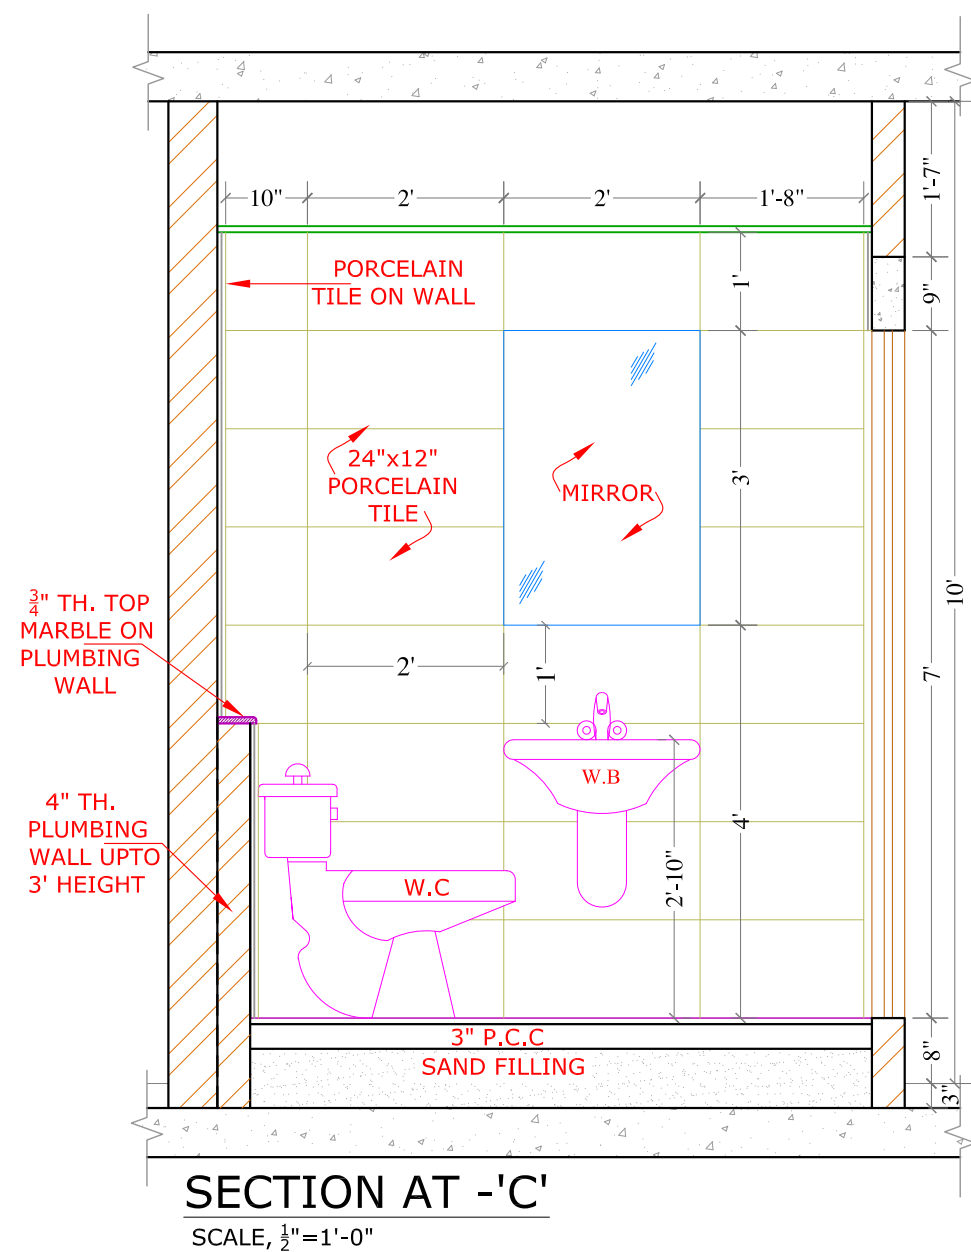


REV.	DATE	DESCRIPTION	BY	CHD	APP
CLIENT SECURITIES AND EXCHANGE COMMISSION OF PAKISTAN PROJECT KARCHI OFFICE DESIGN PHASE TENDER DRAWINGS TITLE BATH DETAIL					
DESIGN SHAZIA QURESHI		DRAWN USMAN HAIDER	SCALE AS SHOWN		
CHECKED SHAZIA QURESHI		APPROVED SHAZIA QURESHI	DATE 30 May, 2020		
NORTH		JOB No. A- 2125			
		DRG. No. A-60			
CONSULTANT: SOHAIL A. KHAN ASSOCIATES Architecture and Designing House #159, Street 4, Race Course Road, Rawalpindi Tel: 5174329 - 5174098; Fax: 5125075 Email: mail@saka.net.pk					
					

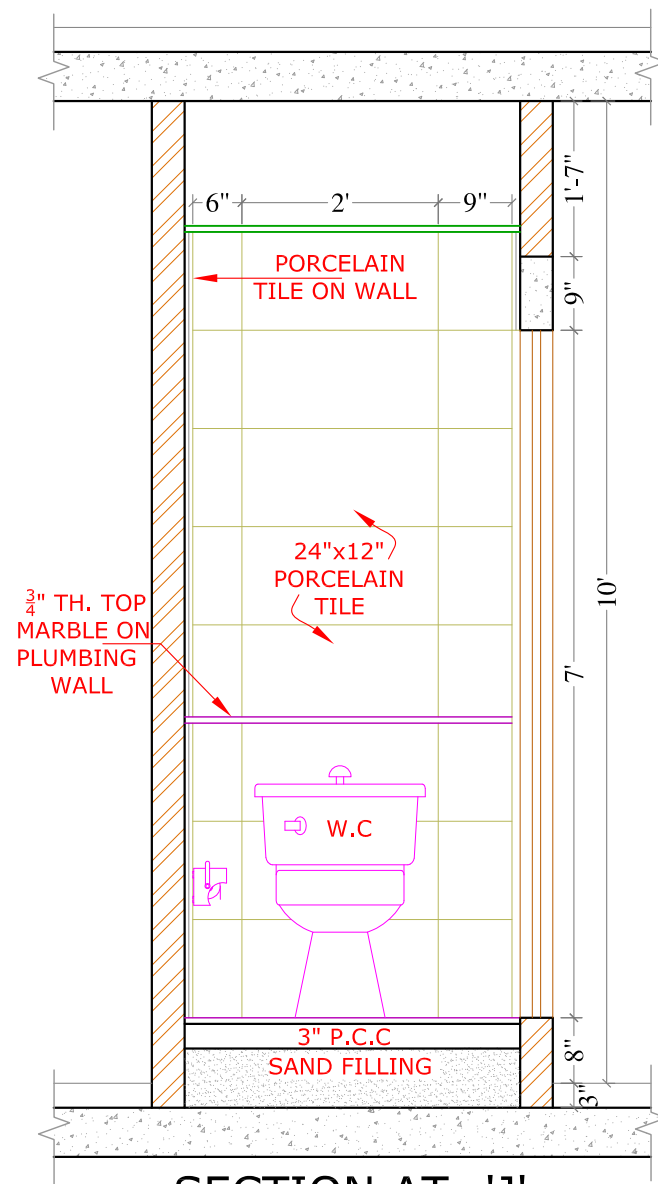


SECTION AT -'J'
SCALE, $\frac{1}{2}$ "=1'-0"

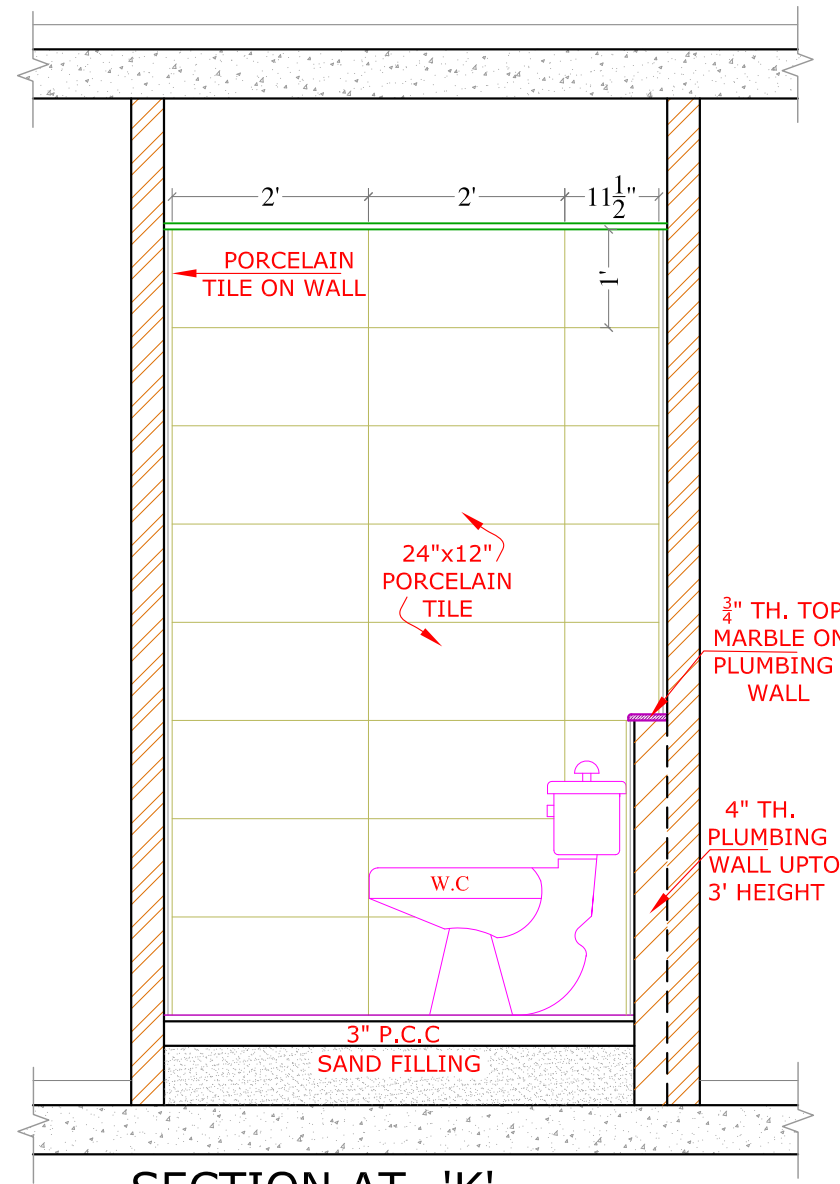

SECTION AT -'K'
SCALE, $\frac{1}{2}$ "=1'-0"




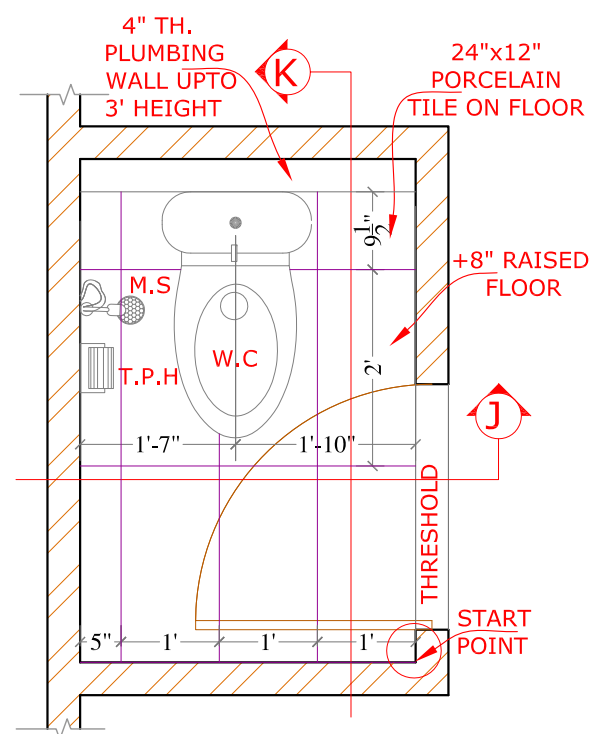


(GENTS) TOILET -01 3'-5"x5'-11 1/2"
SCALE 1/2"=1'-0"

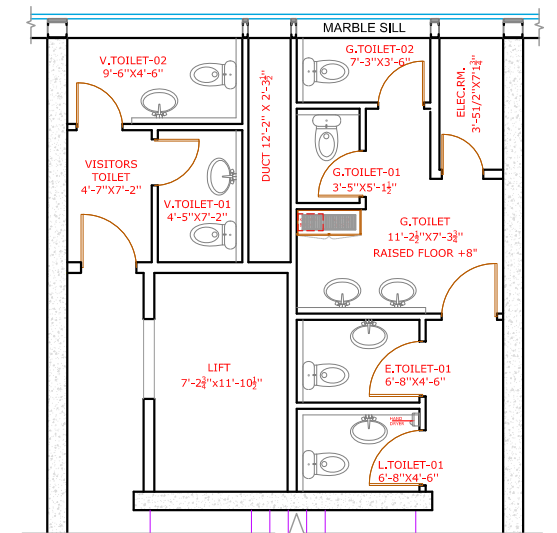


KEYPLAN

REV.	DATE	DESCRIPTION		BY	CHD	APP
CLIENT						
SECURITIES AND EXCHANGE COMMISSION OF PAKISTAN						
PROJECT						
KARCHI OFFICE						
DESIGN PHASE						
TENDER DRAWINGS						
TITLE						
BATH DETAIL						
DESIGN		DRAWN		SCALE		
SHAZIA QURESHI		USMAN HAIDER		AS SHOWN		
CHECKED		APPROVED		DATE		
SHAZIA QURESHI		SHAZIA QURESHI		30 May,2020		
NORTH		JOB No.				
		A- 2125				
		DRG. No.				
		A-61				
CONSULTANT:						
SOHAIL A. KHAN ASSOCIATES						
Architecture and Designing						
House #159, Street 4, Race Course Road, Rawalpindi						
Tel: 5174329 - 5174098; Fax: 5125075						
Email: mail@saka.net.pk						
						

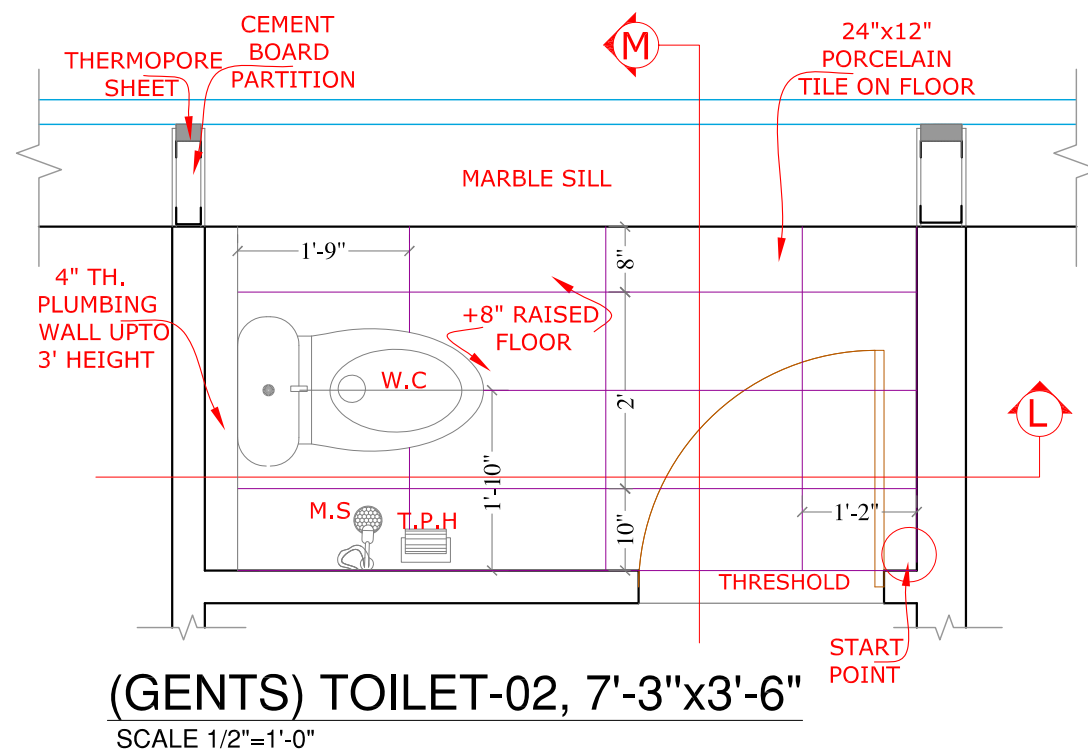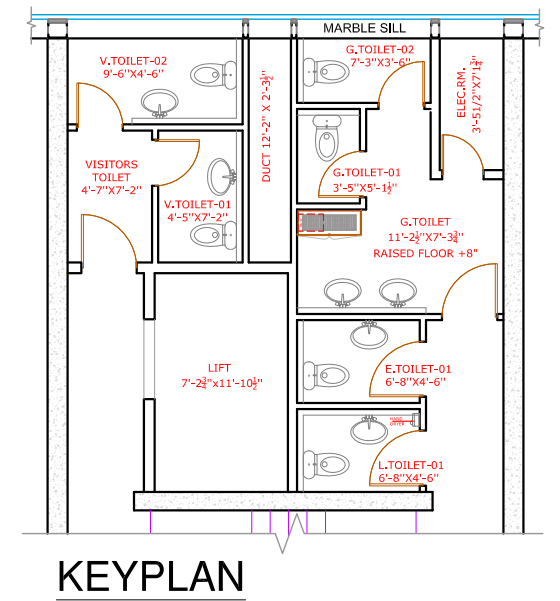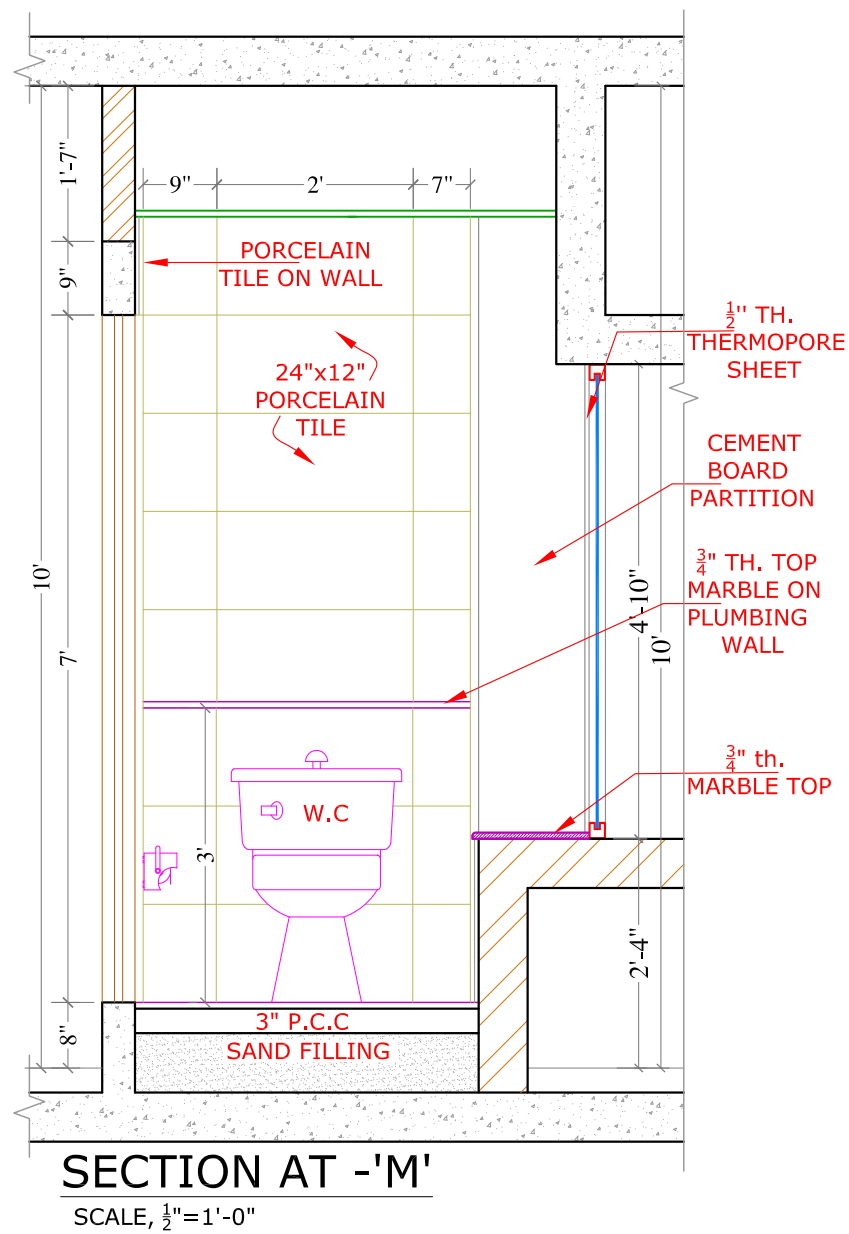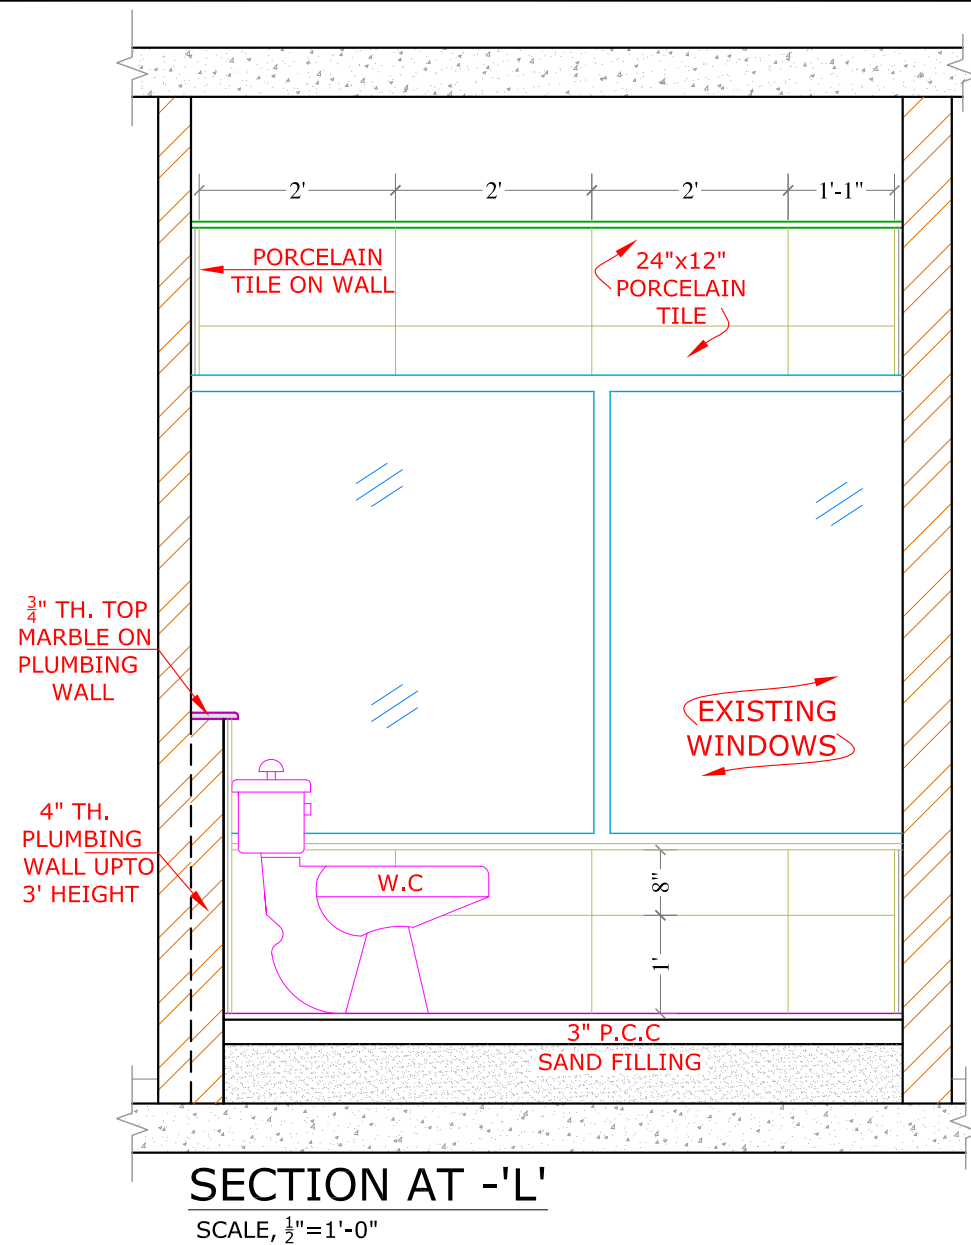


REV.	DATE	DESCRIPTION		BY	CHKD	APP
CLIENT SECURITIES AND EXCHANGE COMMISSION OF PAKISTAN PROJECT KARCHI OFFICE DESIGN PHASE TENDER DRAWINGS TITLE BATH DETAIL						
DESIGN		DRAWN		SCALE		
SHAZIA QURESHI		USMAN HAIDER		AS SHOWN		
CHECKED		APPROVED		DATE		
SHAZIA QURESHI		SHAZIA QURESHI		30 May,2020		
NORTH		JOB No.		A- 2125		
		DRG. No.		A-62		
CONSULTANT: SOHAIL A. KHAN ASSOCIATES Architecture and Designing House #159, Street 4, Race Course Road, Rawalpindi Tel: 5174329 - 5174098; Fax: 5125075 Email: mail@saka.net.pk						

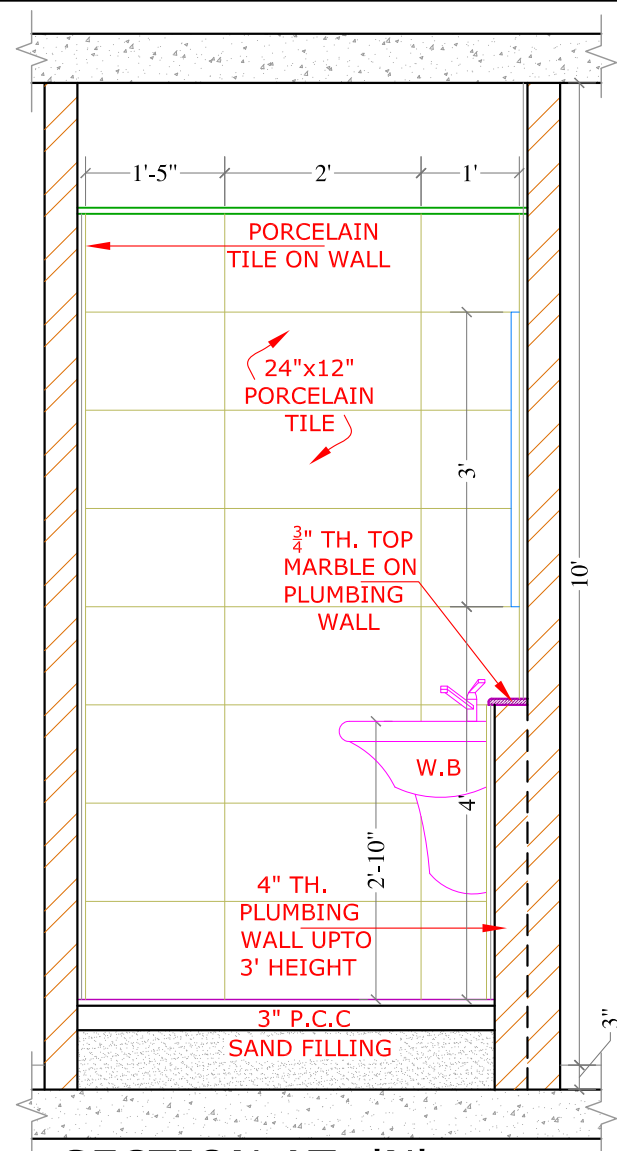


SECTION AT -'N'

SCALE, $\frac{1}{2}$ "=1'-0"

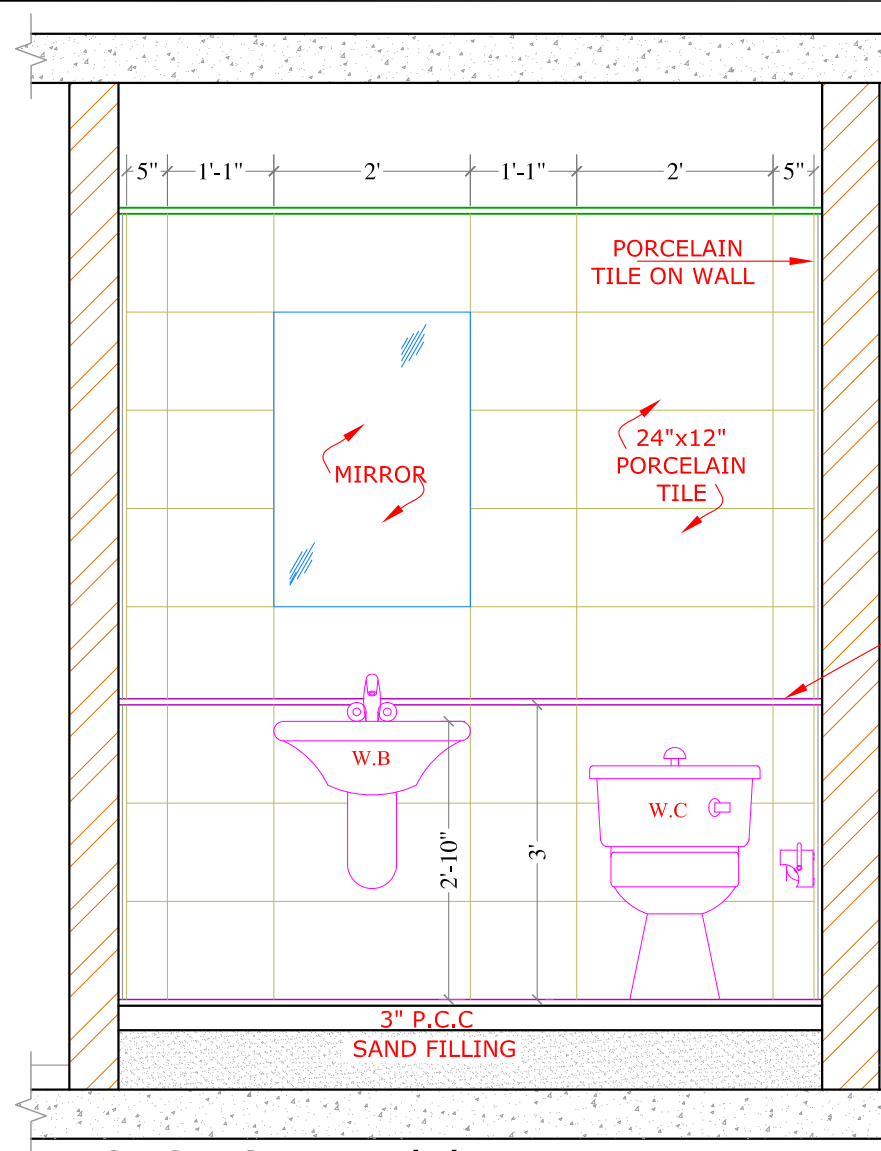


SECTION AT -'P'

SCALE, $\frac{1}{2}$ "=1'-0"

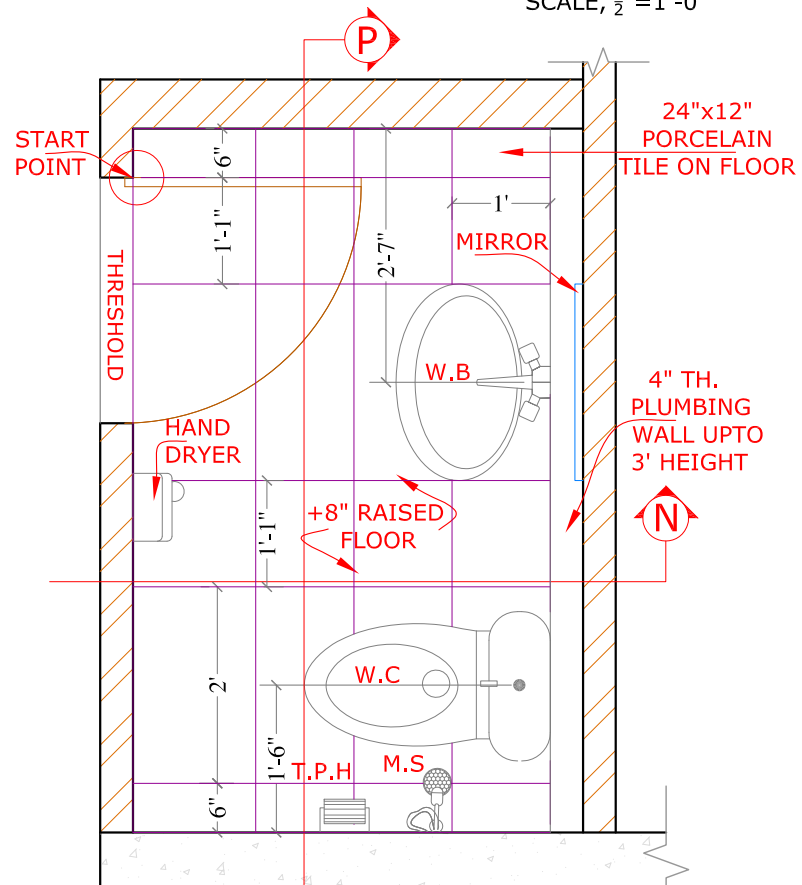


(VISITORS) TOILET-01, 4'-7"x7'-2"

SCALE 1/2"=1'-0"

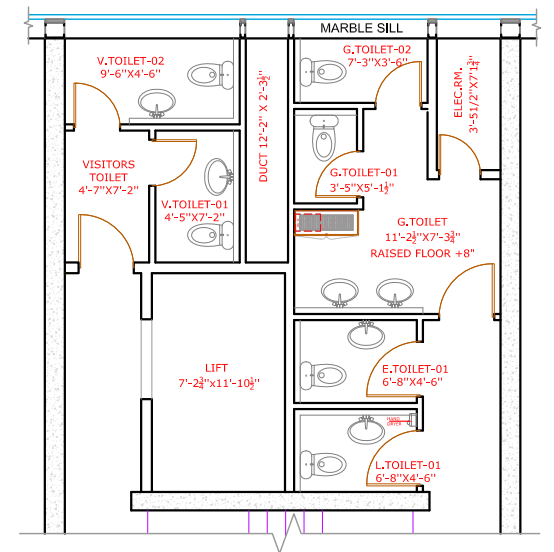


KEYPLAN


REV.	DATE	DESCRIPTION	BY	CHK	APP
CLIENT SECURITIES AND EXCHANGE COMMISSION OF PAKISTAN PROJECT KARCHI OFFICE DESIGN PHASE TENDER DRAWINGS TITLE BATH DETAIL					
DESIGN SHAZIA QURESHI		DRAWN USMAN HAIDER	SCALE AS SHOWN		
CHECKED SHAZIA QURESHI		APPROVED SHAZIA QURESHI	DATE 30 May,2020		
NORTH		JOB No. A- 2125			
		DRG. No. A-63			
CONSULTANT: SOHAIL A. KHAN ASSOCIATES Architecture and Designing House #159, Street 4, Race Course Road, Rawalpindi Tel: 5174329 - 5174098; Fax: 5125075 Email: mail@saka.net.pk					

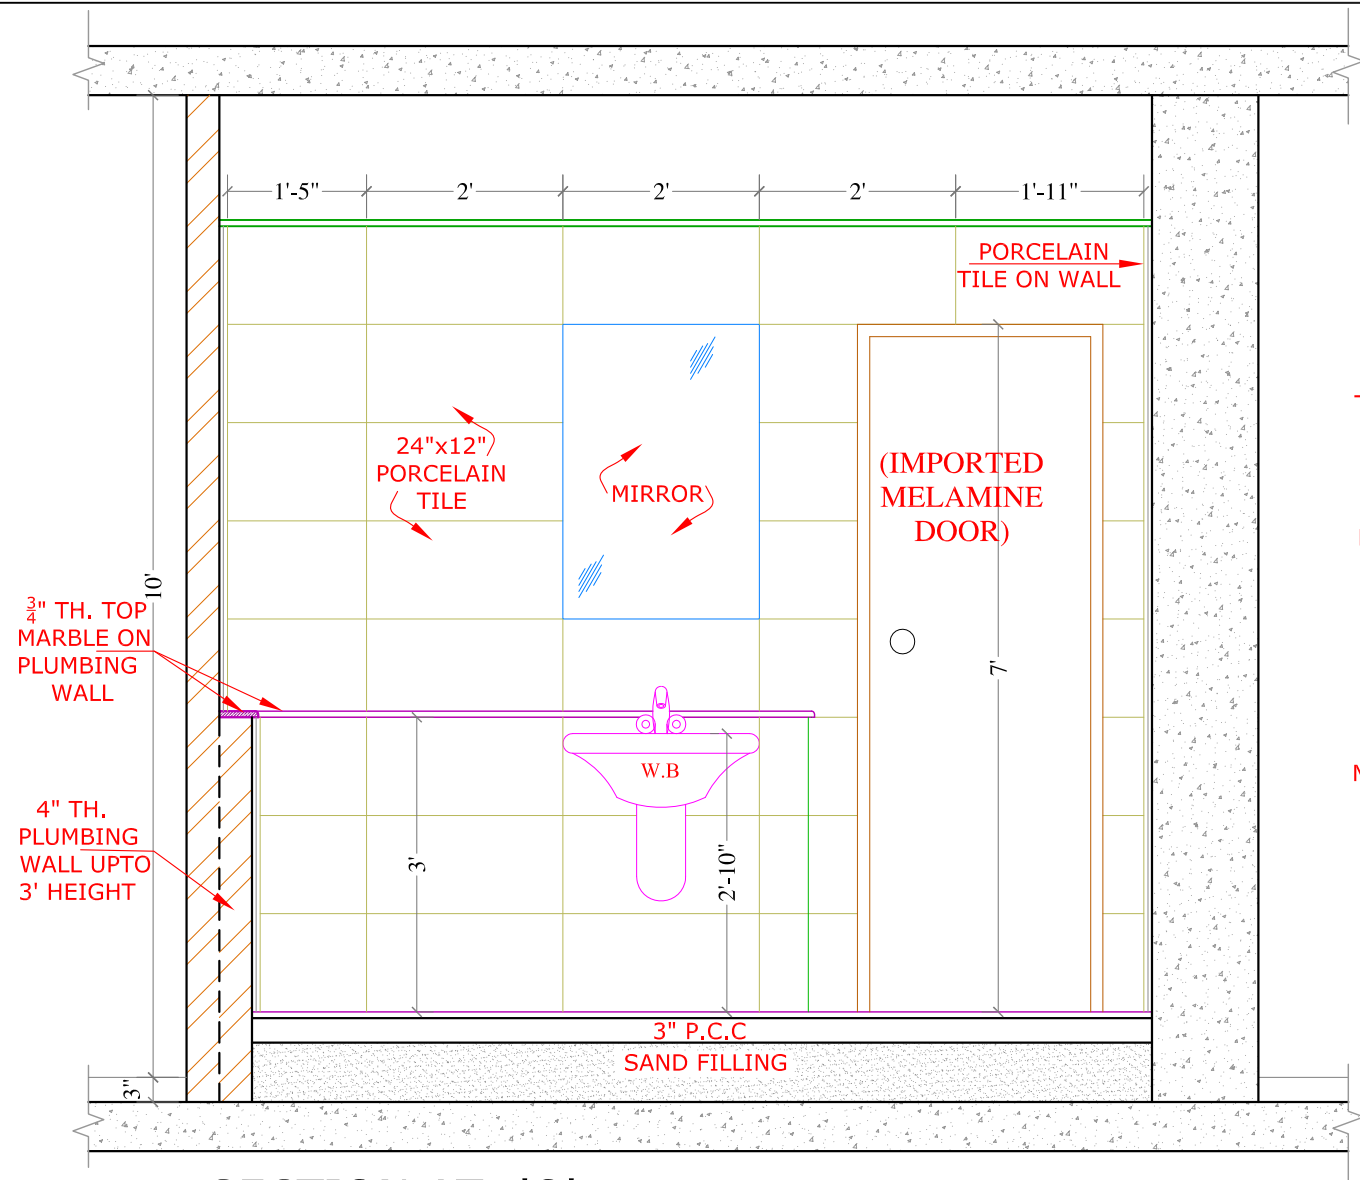


SECTION AT -'Q'
SCALE, 1/2"=1'-0"

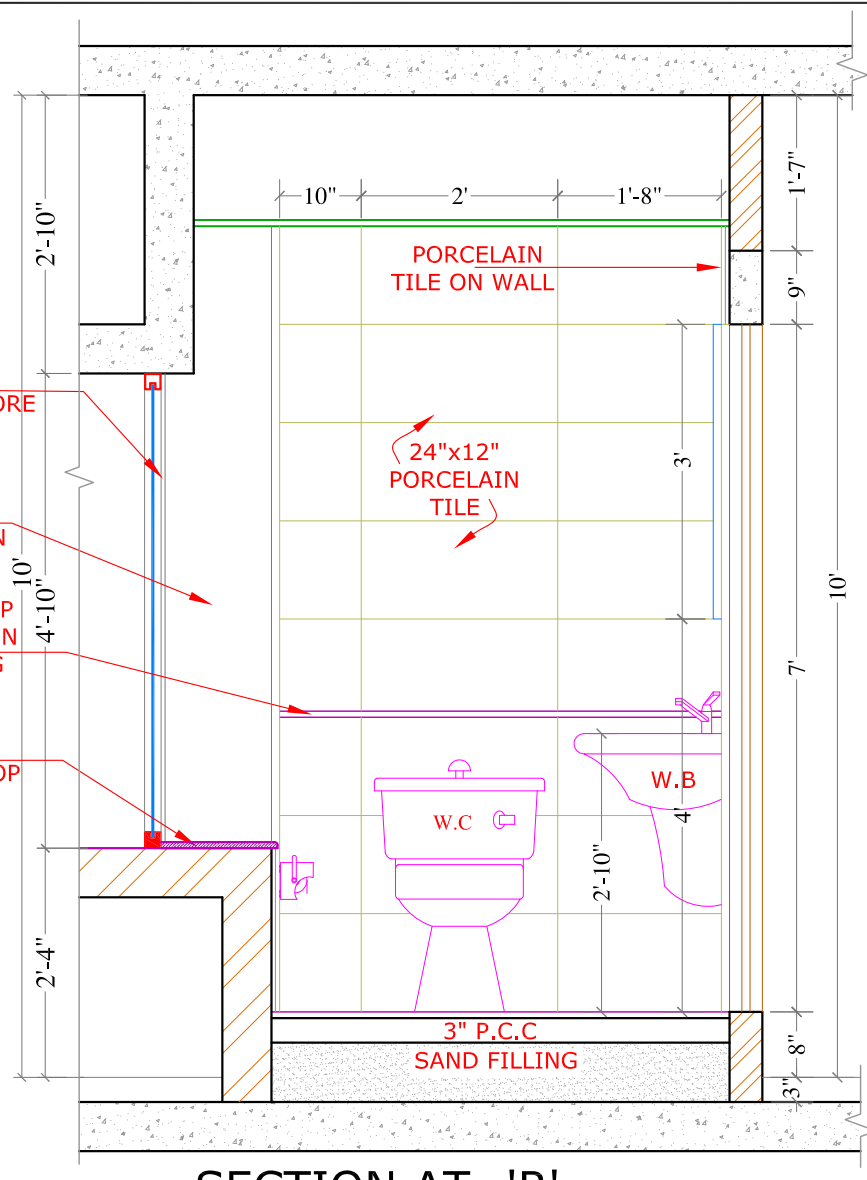

SECTION AT -'R'
SCALE, 1/2"=1'-0"

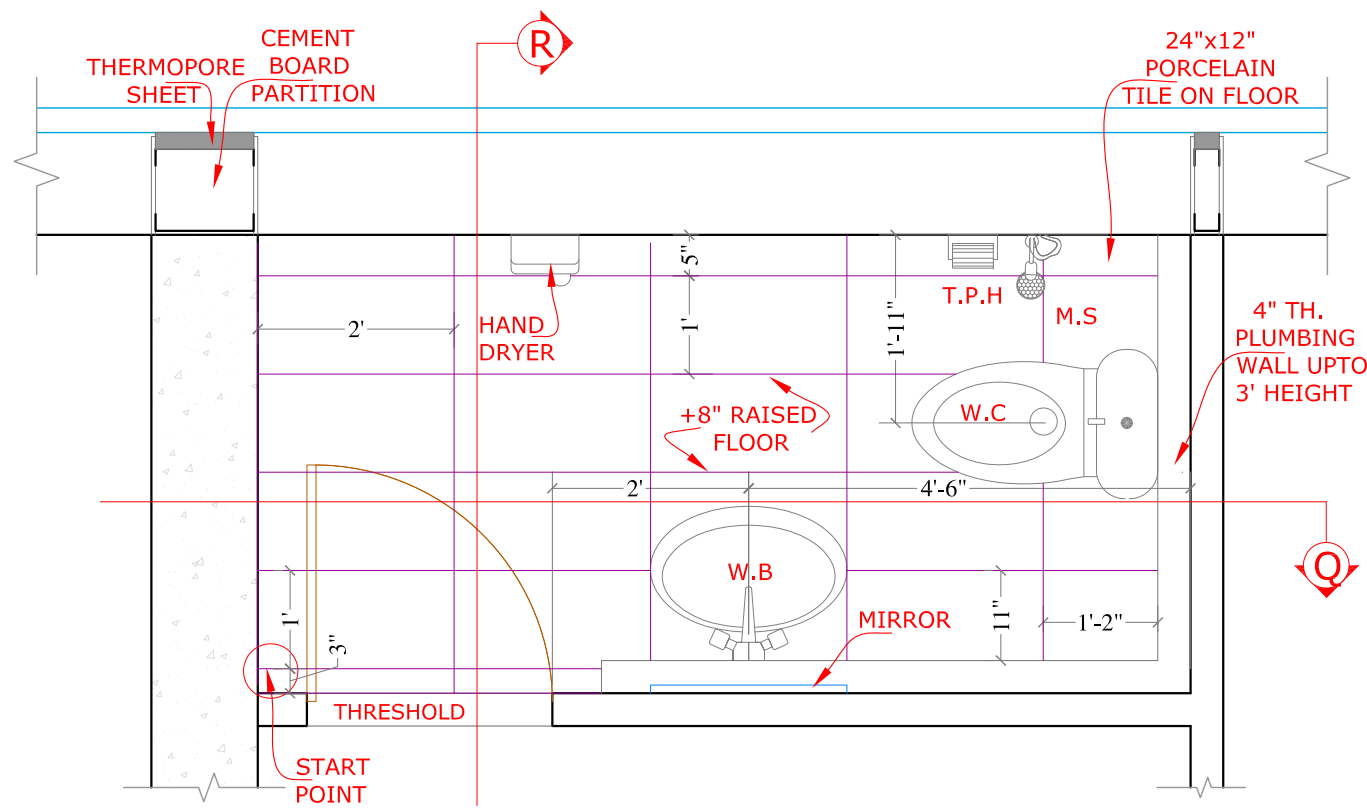


(VISITORS) TOILET-02, 9'-6"x4'-6"
SCALE 1/2"=1'-0"

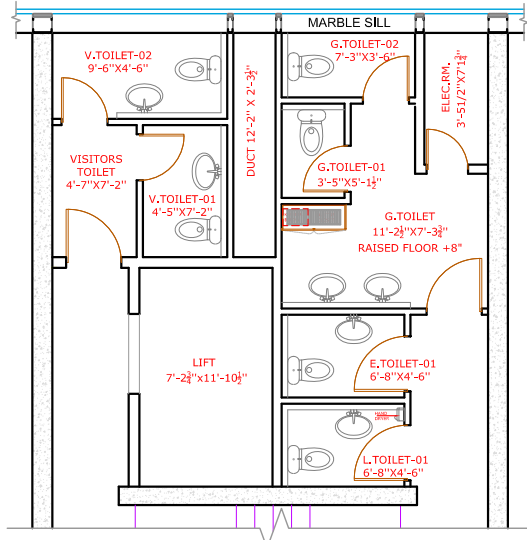


KEYPLAN


REV.	DATE	DESCRIPTION		BY	CHD	APP
CLIENT SECURITIES AND EXCHANGE COMMISSION OF PAKISTAN PROJECT KARCHI OFFICE DESIGN PHASE TENDER DRAWINGS TITLE BATH DETAIL						
DESIGN SHAZIA QURESHI		DRAWN USMAN HAIDER		SCALE AS SHOWN		
CHECKED SHAZIA QURESHI		APPROVED SHAZIA QURESHI		DATE 30 May, 2020		
NORTH		JOB No. A- 2125				
		DRG. No. A-64				
CONSULTANT: SOHAIL A. KHAN ASSOCIATES Architecture and Designing House #159, Street 4, Race Course Road, Rawalpindi Tel: 5174329 - 5174098; Fax: 5125075 Email: mail@saka.net.pk						

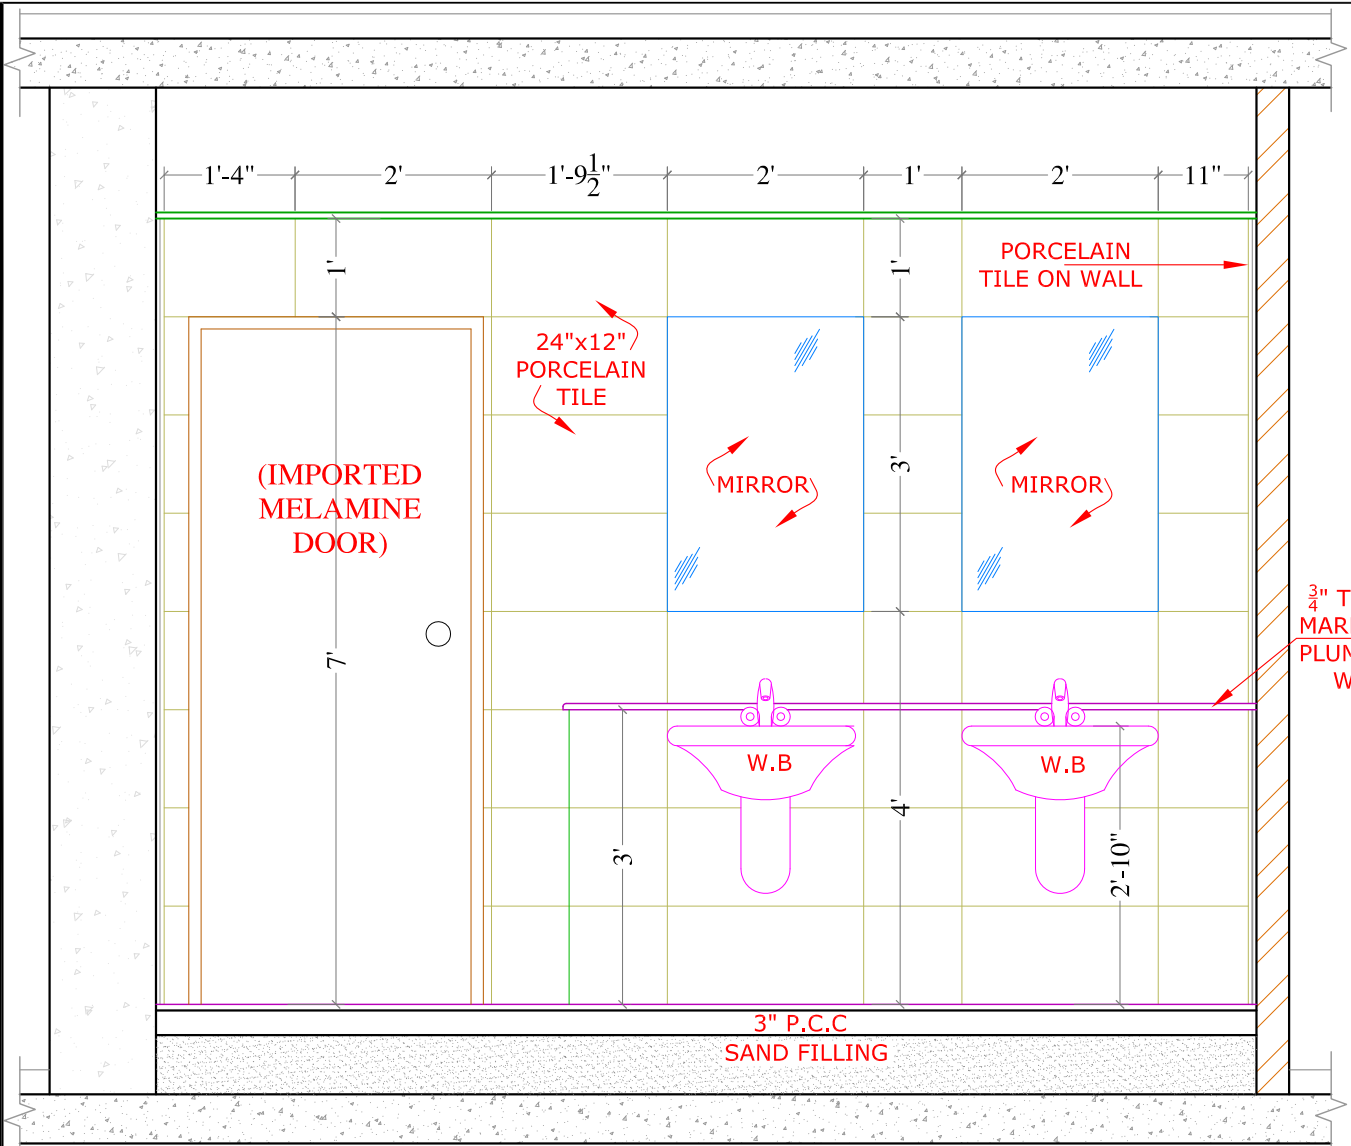


SECTION AT -'E'
SCALE, 1/2"=1'-0"

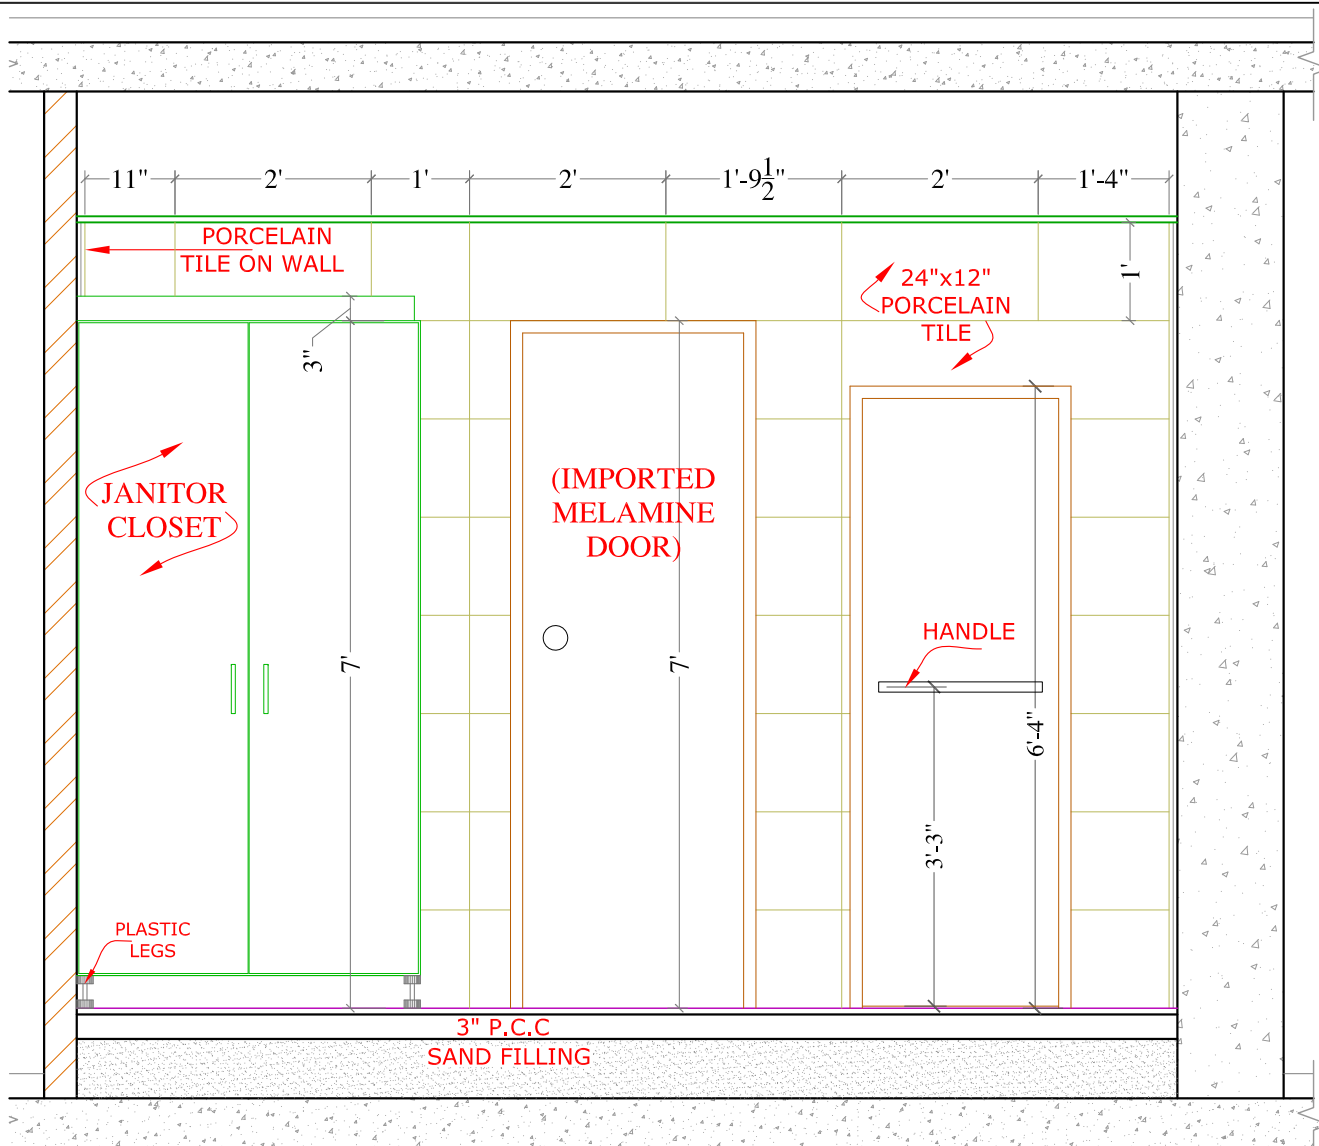

SECTION AT -'F'
SCALE, 1/2"=1'-0"

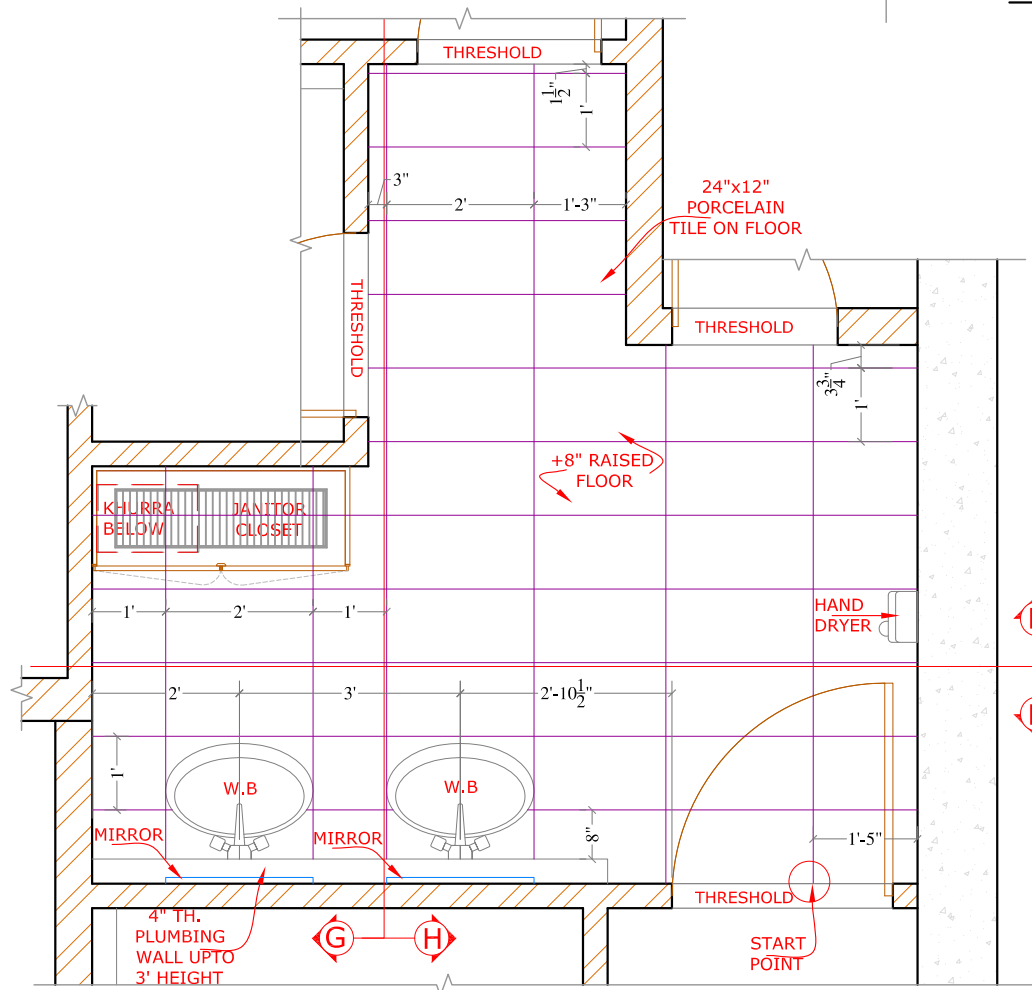



(GENTS).TOILE, 11'-21/2"x5'-6"
SCALE 3/8"=1'-0"

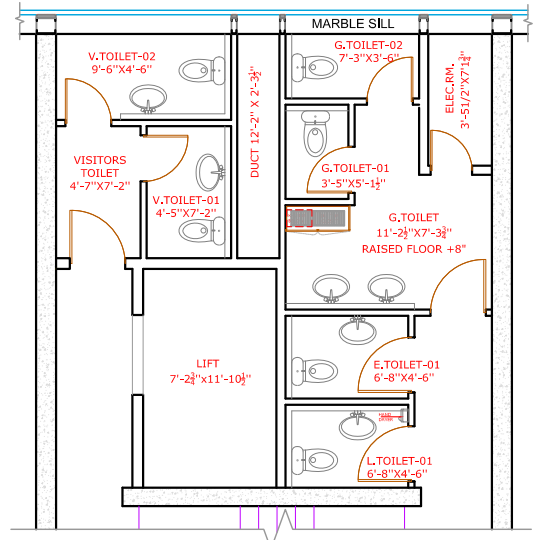


KEYPLAN

REV.	DATE	DESCRIPTION		BY	CHD	APP
CLIENT SECURITIES AND EXCHANGE COMMISSION OF PAKISTAN PROJECT						
KARCHI OFFICE						
DESIGN PHASE						
TENDER DRAWINGS						
TITLE BATH DETAIL						
DESIGN	DRAWN		SCALE			
SHAZIA QURESHI	USMAN HAIDER		AS SHOWN			
CHECKED	APPROVED		DATE			
SHAZIA QURESHI	SHAZIA QURESHI		30 May, 2020			
NORTH	JOB No. A- 2125					
	DRG. No. A-65					
CONSULTANT: SOHAIL A. KHAN ASSOCIATES Architecture and Designing House #159, Street 4, Race Course Road, Rawalpindi Tel: 5174329 - 5174098; Fax: 5125075 Email: mail@saka.net.pk						

 


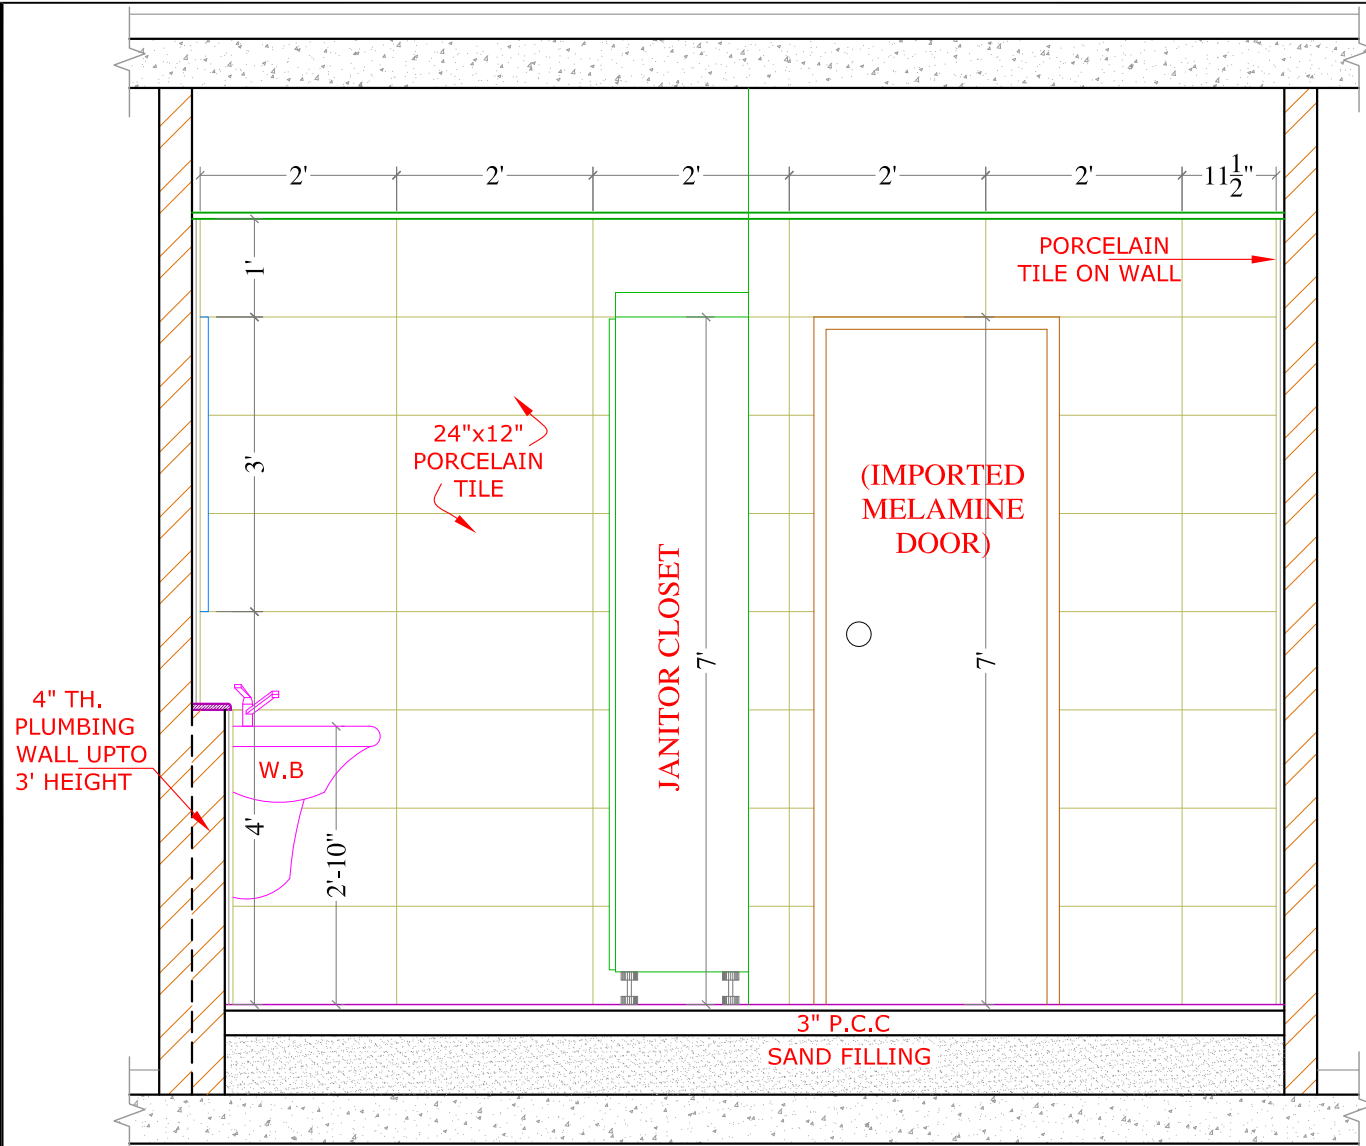


SECTION AT -'G'
SCALE, 1/2"=1'-0"

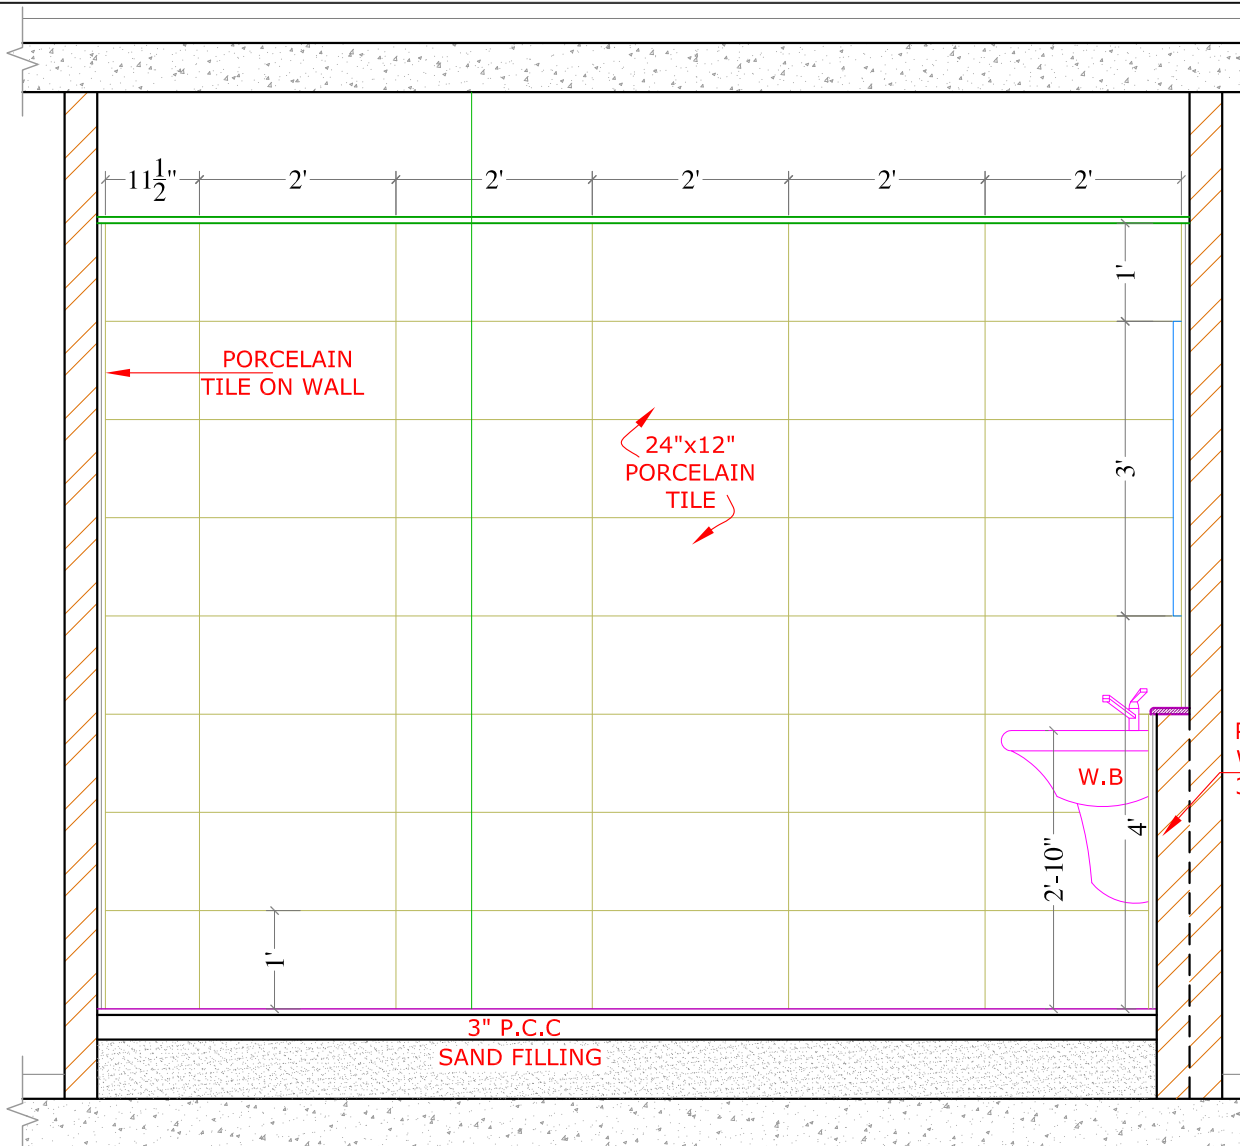

SECTION AT -'H'
SCALE, 1/2"=1'-0"

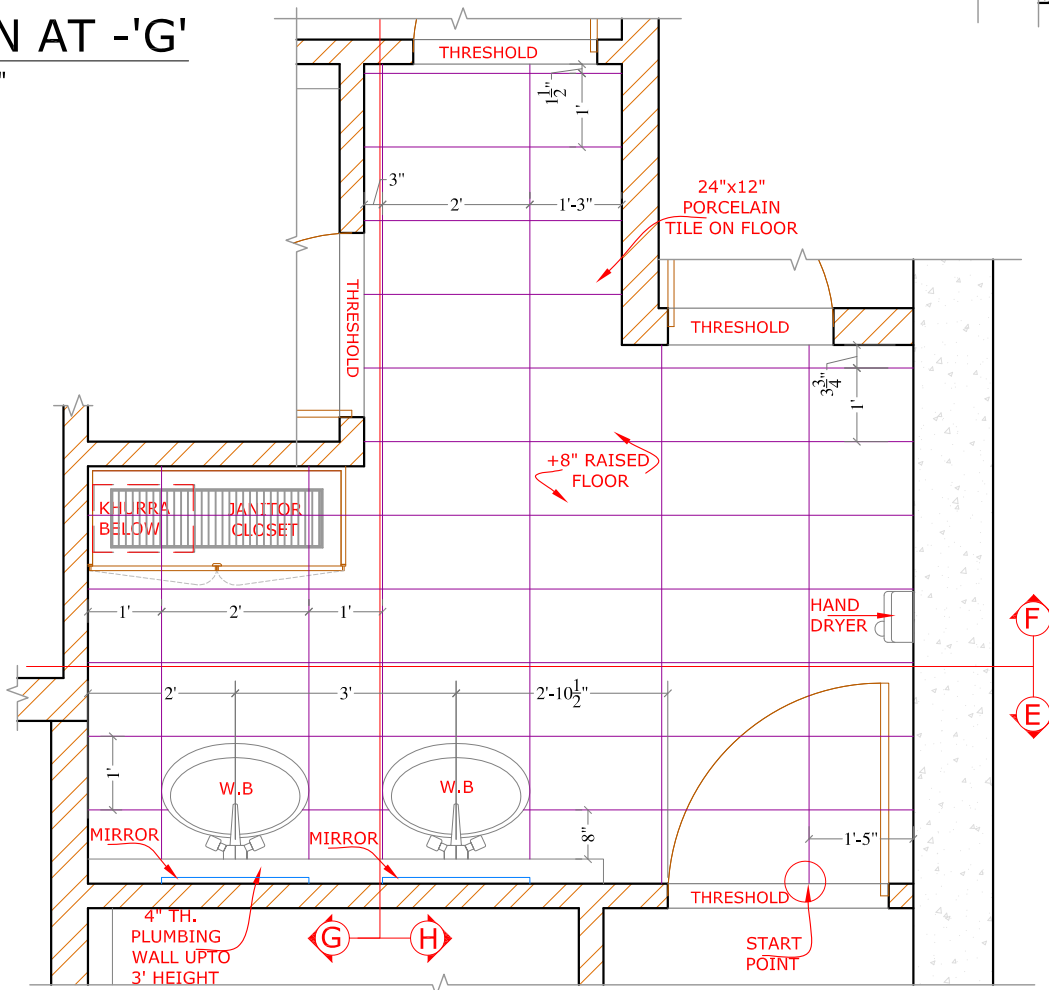

(GENTS).TOILE, 11'-21 1/2"x5'-6"
SCALE 3/8"=1'-0"

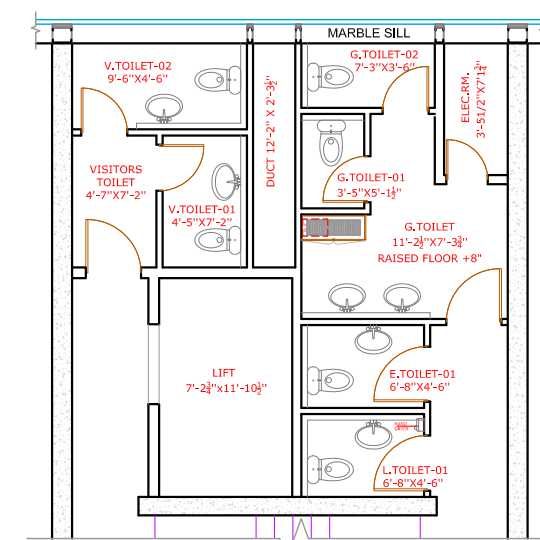


KEYPLAN

REV.	DATE	DESCRIPTION	BY	CHD	APP
CLIENT SECURITIES AND EXCHANGE COMMISSION OF PAKISTAN PROJECT					
KARCHI OFFICE					
DESIGN PHASE					
TENDER DRAWINGS					
TITLE BATH DETAIL					
DESIGN	SHAZIA QURESHI	DRAWN	USMAN HAIDER	SCALE	AS SHOWN
CHECKED	SHAZIA QURESHI	APPROVED	SHAZIA QURESHI	DATE	30 May, 2020
NORTH	JOB No. A- 2125				
DRG. No. A-66					
CONSULTANT: SOHAIL A. KHAN ASSOCIATES Architecture and Designing House #159, Street 4, Race Course Road, Rawalpindi Tel: 5174329 - 5174098; Fax: 5125075 Email: mail@saka.net.pk					



ELECTRIFICATION

SOHAIL A. KHAN ASSOCIATES
Architecture and Designing
House #159, Street 4, Race Course Road, Rawalpindi
Tel: 5174329 - 5174098; Fax: 5125075
Email: mail@saka.net.pk

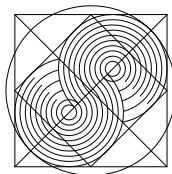

RAAHIM ASSOCIATES
M.E.P ENGINEERS & CONSULTANT
FLAT 07, 1F SHERAZ PLAZA, GULBERG II, LHR
Ph: 042-35764449, Cell no: 0333-4320990
E-mail: raahimassociates@gmail.com

LIGHT FIXTURES

S.NO	SYMBOLS	DESCRIPTION	MOUNTING HEIGHT
1		PICTURE/MIRROR LIGHT WALL MOUNTED FIXTURE WITH 8 WATT LED ROD AND DRIVER	AS PER THE BOQ
2		LED LIGHT FIXTURE WITH 3W/4W WATT SMD	AS PER THE BOQ
3		LED LIGHT FIXTURE WITH 7W/9W WATT SMD	AS PER THE BOQ
4		LED LIGHT FIXTURE WITH 3W COB	AS PER THE BOQ
5		HANGING LIGHT FIXTURE WITH LED 12W/15W	AS PER THE BOQ
6		HANGING LED LIGHT FIXTURE 2'x2' 45 WATT / 36 WATT	AS PER THE BOQ
7		4 FEET LONG 1x30 WATT LED LINEAR LIGHT	AS PER THE BOQ
8		ROPE LIGHT	AS PER THE BOQ
9		PRESENCE DETECTOR	AS PER THE BOQ
10		BATTERY OPERATED EXIT LIGHT	AS PER THE BOQ
11		BATTERY OPERATED DIRECTIONAL EXIT LIGHT	AS PER THE BOQ
12		BATTERY OPERATED EMERGENCY LIGHT FIXTURE	AS PER THE BOQ
13		EXHAUST FAN	AS PER THE BOQ

TV SYSTEM

S.NO	SYMBOLS	DESCRIPTION	MOUNTING HEIGHT
1		TV OUTLET POINT	IN FOB OR ON WALL AT 0'-9" F.F.L
2		TV JUNCTION BOARD	0'-9" F.F.L
3		TV SPLITTER	RACK MOUNTED
4		WIRING IN 1/2 PVC FOR TV SYSTEM	IN WALL BUF/BUG/BIS

Q-MATIC SYSTEM

S.NO	SYMBOLS	DESCRIPTION	MOUNTING HEIGHT
1		Q-MATIC PANEL	AS PER SITE
2		Q-MATIC KEYPAD	AS PER SITE
3		Q-MATIC DISPLAY	AS PER SITE
4		Q-MATIC COUNTER DISPLAY	AS PER SITE

WIRING ACCESSORIES

S.NO	SYMBOLS	DESCRIPTION	MOUNTING HEIGHT
1		10 AMPS, ONE WAY AND TWO WAYS GANG TYPE SWITCH	3'-6" F.F.L
2		5 AMPS 3-PIN COMBINED SWITCH SOCKET	0'-9" F.F.L
3		5 AMPS 3-PIN COMBINED SWITCH SOCKET	3'-6" F.F.L
4		3 PIN FLAT SWITCH SOCKET 13 AMPS,	0'-9" F.F.L
5		15 AMPS 3-ROUND PIN SWITCH SOCKET	0'-9" F.F.L
6		15 AMPS 3-ROUND PIN SWITCH SOCKET	3'-6" F.F.L
7		SPLIT AC	8'-0" F.F.L OR AS REQ.
8		CASSETTE AIR CONDITIONER	ON SLAB
9		TECHNOLOGY BOX MADE OF MS SHEET OF 16 SWG OF SIZE 14"x14", CONSISTING OF 1- 5 AMPS SWITCH SOCKET ON NORMAL SUPPLY 2- 13 AMPS UNIVERSAL SOCKET ON UPS SUPPLY 3- RJ-45 DUPLEX, 1 NO. FOR DATA AND 1 NO. FOR TELEPHONE	2'-6" F.F.L
10		TECHNOLOGY BOX MADE OF MS SHEET OF 16 SWG OF SIZE 14"x14", CONSISTING OF 1- 5 AMPS SWITCH SOCKET ON NORMAL SUPPLY 2- 13 AMPS UNIVERSAL SOCKET ON UPS SUPPLY 3- RJ-45 DUPLEX, 1 NO. FOR DATA AND 1 NO. FOR TELEPHONE	ON FLOOR
11		WIRING IN 1/2" PVC CONDUIT	-IN WALL/ -BUF/BUG/ BIS
12		DISTRIBUTION BOARD FOR LIGHTING CIRCUIT & SMALL POWER	4'-0" F.F.L OR AS REQ.

FIRE ALARM SYSTEM

S.NO	SYMBOLS	DESCRIPTION	MOUNTING HEIGHT
1		HEAT DETECTOR RATE OF TEMPERATURE TYPE	ON FALSE CEILING/SLAB
2		SMOKE DETECTOR NON IONIZATION TYPE.	ON FALSE CEILING/SLAB
3		GAS DETECTOR	ON FALSE CEILING/SLAB
4		ALARM SOUNDER	7'-0" F.F.L
5		MANUAL BREAK GLASS CALL STATION	4'-0" F.F.L
6		FIRE ALARM CONTROL PANEL	4'-0" F.F.L
7		FIRE ALARM JUNCTION BOARD	1'-6" F.F.L
8		INDICATES WIRING IN 1/2" PVC FOR FIRE ALARM SYSTEM	ON SLAB AFC

CLOSE CIRCUIT T.V SYSTEM

S.NO	SYMBOLS	DESCRIPTION	MOUNTING HEIGHT
1		MONITOR	AS PER SITE
2		CLOSE CIRCUIT TV CAMERA	-ON WALL 7'-0" -ON SLAB
3		CCTV JUNCTION BOX	6" TO 9" BELOW SLAB BUT ABOVE FALSE CEILING
4		WIRING IN 1/2" PVC FOR CCTV SYSTEM	ON SLAB/ BUG/BUF/BIS
5		NETWORK VIDEO RECORDER	AS PER SITE

TELEPHONE SYSTEM

S.NO	SYMBOLS	DESCRIPTION	MOUNTING HEIGHT
1		TELEPHONE OUTLET WITH RJ-11 ON M.S	IN FOB OR ON WALL AT 0'-9" F.F.L
2		INDICATES TELEPHONE OUTLET WITH RJ-45 ON M.S JUNCTION BOX 3"x3"	0'-9" F.F.L OR AS REQ.
3		TELEPHONE JUNCTION BOARD	0'-9" F.F.L
4		WIRING IN 1/2" PVC FOR TELEPHONE SYSTEM	IN WALL BUF/BUG/BIS
5		MAIN DISTRIBUTION FRAME	AS PER SITE

DATA SYSTEM

S.NO	SYMBOLS	DESCRIPTION	MOUNTING HEIGHT
1		DATA OUTLET WITH RJ-45 SOCKET	0'-9" F.F.L
2		DATA POINT	0'-9" F.F.L
3		DATA NETWORKING SWITCH	4'-0" F.F.L
4		DATA JUNCTION BOARD	0'-9" F.F.L
5		WIRING IN 1/2" PVC FOR TELEPHONE SYSTEM	IN WALL BUF/BUG/BIS
6		WIFI ROUTER	ON SLAB

ACCESS CONTROL PANEL

S.NO	SYMBOLS	DESCRIPTION	MOUNTING HEIGHT
1		CARD READER	AS PER SITE
2		UNLOCK PUSH POINT	AS PER SITE
3		ACCESS CONTROL PANEL	AS PER SITE
4		ACCESS CONTROL JUNCTION BOX	AS PER SITE

CLIENT:

SECURITIES AND EXCHANGE
COMMISSION OF PAKISTAN

 
PROJECT:

INTERIOR RENOVATION
4TH FLOOR COMPANIES

CONSULTANT:

SOHAIL A. KHAN ASSOCIATES
Architecture and Designing

House #159, Street 4, Race Course Road, Rawalpindi
Tel: 5174329 - 5174098; Fax: 5125075
Email: mail@saka.net.pk



MEP CONSULTANT:



RAAHIM ASSOCIATES

MEP ENGINEERS & CONSULTANT
FLAT 07, 1F SHERAZ PLAZA, GULBERG II, LHR
Ph: 042-35764449, Cell no: 0333-4320990
E-mail: raahimassociates@gmail.com

DRAWING TITLE:

MAIN LEGEND

DESIGN BY:

CH.USAMA

SCALE:

N.T.S

DRAWN BY:

M.AKRAM

DATE:


15.06.2020

CHECK BY:


S.Y.B

DWG.NO:

E-01

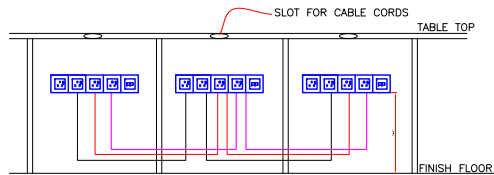


TYPICAL ARRANGMENTS OF TECHNOLOGY BOARD
& CONDUITS FIXED ON WORK STATION

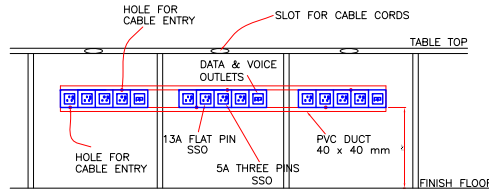

TYPICAL ARRANGMENTS OF TECHNOLOGY BOARD
& PVC DUCTS FIXED ON WORK STATION



EARTHING DETAIL BORE TYPE

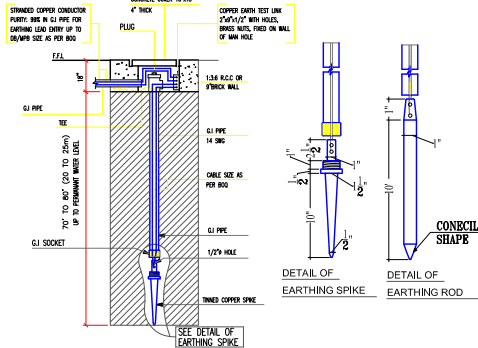


SEE DETAIL-C

GENERAL & WIRING NOTES:-


- ALL ELECTRICAL WORKS PERTAINING TO WIRING OF ELECTRICAL SYSTEMS SHALL STRICTLY CONFORM TO I.E.E LATEST EDITION OF RULES & REGULATIONS.
- ALL WIRING SHALL BE DONE IN PVC CONDUIT TO BE CONCEALED IN WALLS, SLABS, COLUMNS AND FLOOR OR AS SHOWN ON DRAWINGS.
- THE WIRING SHOULD BE STARTED ONLY AFTER THE CONDUIT SYSTEM HAS BEEN COMPLETED AND ALL OUTLET BOXES ARE FIXED AT THEIR RESPECTIVE POSITIONS.
- ALL PVC CONDUITS SHALL BE OF 3/4" OR 1" Ø (DEPENDENT UPON NUMBER OF WIRES) FROM SWITCH BOARD TO LIGHT POINTS & 1" DIA FROM DBs TO SWITCH BOARDS AND POWER SOCKETS OR AS SHOWN ON DRAWINGS.
- LIGHT / FAN POINT CONTROLLED BY ONE WAY SWITCH. WIRED WITH 2x1.5mm sq (3/0.029") FOR (P+N) 1x2.5mm sq (7/0.029") AS EARTH(E) WIRE.
- LIGHTING CIRCUITS FROM RESPECTIVE DB TO SWITCH SOCKET WIRED WITH 3x2.5mm sq (7/0.029") AS P+N+E
- SOCKETS WIRED IN PARALLEL WITH 3x2.5mm sq AS P+N+E
- POWER SOCKETS WIRED WITH 3x4mmSq AS P+N+E
- SA/C 1-1.5 TON WIRED WITH 3x6mmSq AS P+N+E
- SA/C 2- 2.5 TON WIRED WITH 3x6mmSq AS P+N+E
- NO LUBRICATION EXCEPT AS RECOMMENDED BY MANUFACTURER SHALL BE USED FOR PULLING OF WIRES IN PVC CONDUITS. NO OIL OF ANY KIND SHALL BE USED.
- COLOUR CODING FOR WIRING SHALL BE AS FOLLOWS: RED, YELLOW AND BLUE FOR PHASES, BLACK FOR NEUTRAL AND GREEN / YELLOW FOR CPC (EARTH).
- ALL LIGHT POINTS AND POWER SOCKETS SHALL BE PROPERLY EARTHED WITH 2.5mm sq PVC INSULATED WIRES OF COLOUR GREEN-YELLOW.
- THE NUMBER OF WIRES TO BE PULLED IN ANY CONDUIT FOR WIRING PURPOSES SHALL CONFORM TO IEE. TABLE
- 1" DIA PVC CONDUIT SHALL BE USED FOR WIRING OF ALL OTHER SYSTEMS UNLESS OTHERWISE MENTIONED ON PLANS OR AS SPECIFIED IN BOQ.
- ELECTRICAL CONTRACTOR TO CONSULT ELECTRICAL CONSULTANT/ENGINEER FOR ANY FURTHER CLARIFICATIONS. NO ASSUMPTIONS SHOULD BE MADE.

NOTES FOR EARTHING SYSTEM

- EARTH BORE SHALL BE MADE AT 6'-0" AWAY FROM FOUNDATION.
- DISTANCE BETWEEN 2 EARTH BORES SHALL NOT BE GREATER THEN 10ft (3m)
- COPPER CONDUCTOR AT TOP OF G.I. PIPE SHALL BE BOLTED WITH THIMBLES, BRASS NUTS, BOLTS ETC.
- JOINTS SHALL BE COVERED WITH BITUMEN
- CONTRACTOR TO MEASURE EARTHING RESISTANCE IN THE PRESENCE OF SITE ENGINEER. BOTH THE SITE ENGINEER AND CONTRACTOR SHALL SIGN THE EARTH TESTING RESULT AND SUBMIT IT TO THE CONSULTANT.



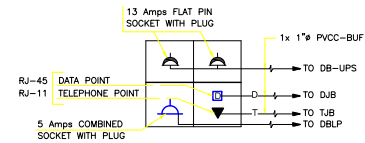


TENTATIVE DETAIL OF FLOOR OUTLET PLATE

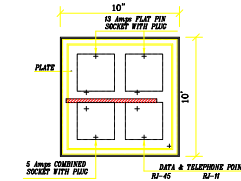

TENTATIVE DETAIL OF M.S FLOOR OUTLET BOX- (FOB)

- BURIED PLUSH WITH FINISHED FLOOR LEVEL
- SAMPLE TO BE SUBMITTED TO CONSULTANT FOR APPROVAL SEE BOQ

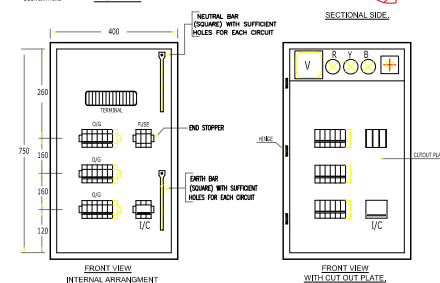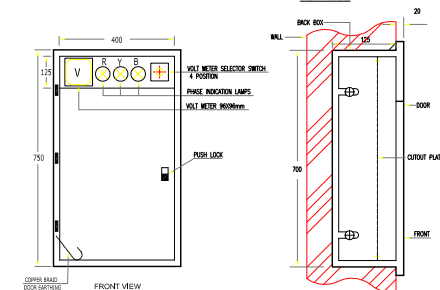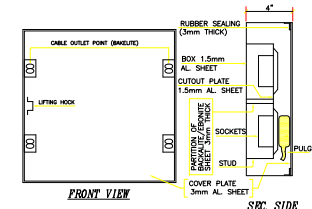

TENTATIVE CONSTRUCTIONAL DETAIL OF-
DISTRIBUTION BOARD (FOR PRECESSED TYPE)


CLIENT:
SECURITIES AND EXCHANGE
COMMISSION OF PAKISTAN
PROJECT:
INTERIOR RENOVATION
4TH FLOOR COMPANIES

CONSULTANT:
SOHAIL A. KHAN ASSOCIATES
Architecture and Designing
House #159, Street 4, Race Course Road, Rawalpindi
Tel: 5174329 - 5174098; Fax: 5125075
Email: mail@saka.net.pk

MEP CONSULTANT:
RAAHIM ASSOCIATES
MEP ENGINEERS & CONSULTANT
FLAT 07, 1F SHERAZ PLAZA, GULBERG II, LHR
Ph: 042-35764449, Cell no: 0333-4320990
E-mail: raahimassociates@gmail.com

DRAWING TITLE:
GENERAL WIRING NOTES, TENTATIVE
CONSTRUCTIONAL DETAIL OF
DISTRIBUTION BOARD, TECHNOLOGY,
FLOOR BOX AND EARTHING DETAIL

DESIGN BY: CH.USAMA
DRAWN BY: M.AKRAM
CHECK BY: S.Y.B
SCALE: N.T.S
DATE: 15.06.2020
DWG.NO: E-02

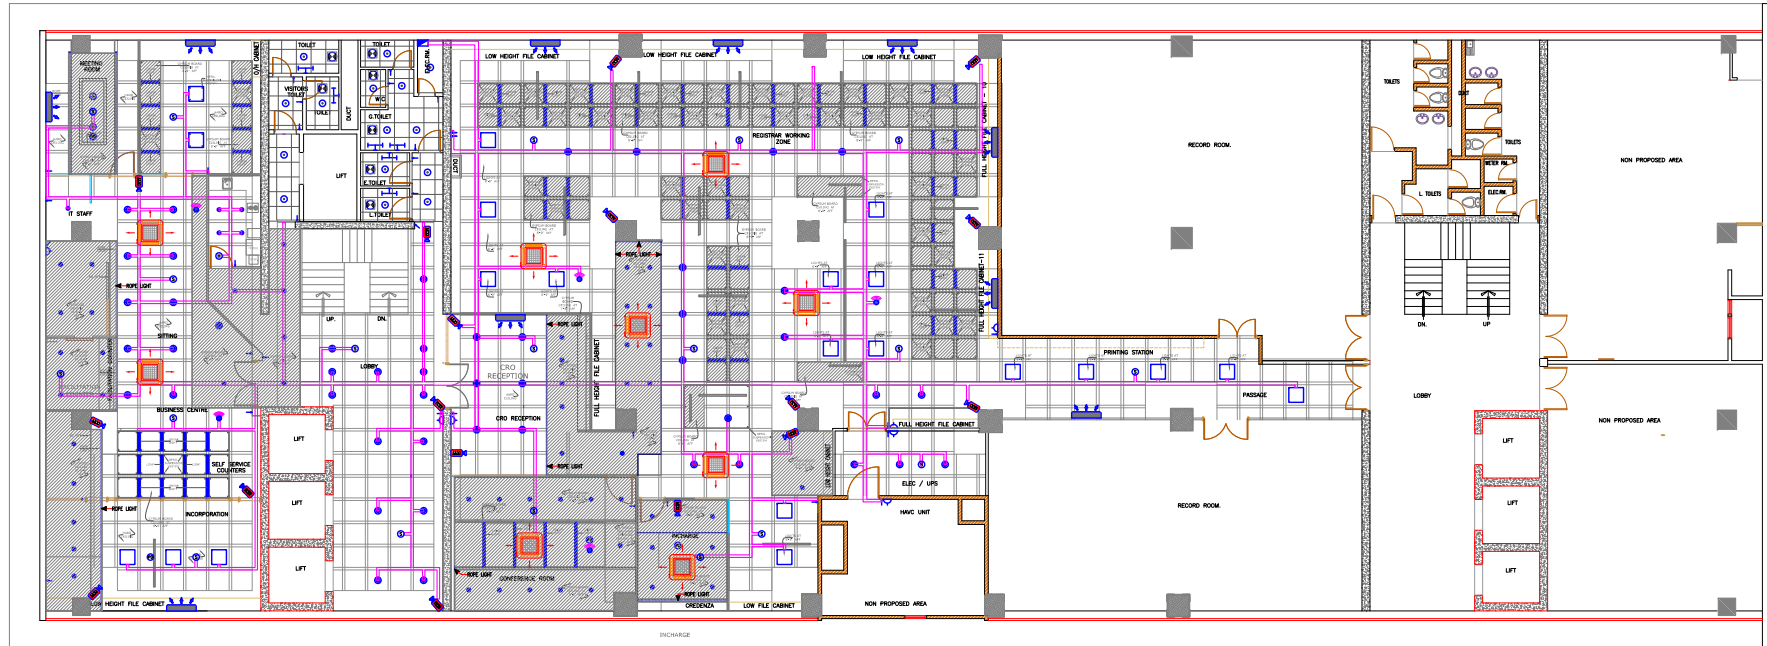

INCORPORATION

CLIENT:
SECURITIES AND EXCHANGE
COMMISSION OF PAKISTAN


PROJECT:
INTERIOR RENOVATION
4TH FLOOR COMPANIES

CONSULTANT:
SOHAIL A. KHAN ASSOCIATES
Architecture and Designing
House #159, Street 4, Race Course Road, Rawalpindi
Tel: 5174329 - 5174098; Fax: 5125075
Email: mail@saka.net.pk

MEP CONSULTANT:
RAAHIM ASSOCIATES
MEP ENGINEERS & CONSULTANT
FLAT 07, 1F SHERAZ PLAZA, GULBERG II, LHR
Ph: 042-35764449; Cell no: 0333-4320990
E-mail: raahimassociates@gmail.com

DRAWING TITLE:
CEILING CO-ORDINATION LAYOUT

DESIGN BY: CH.USAMA	DRAWN BY: M.AKRAM	CHECK BY: S.Y.B
SCALE: N.T.S	DATE: 15.06.2020	DWG.NO: E-03

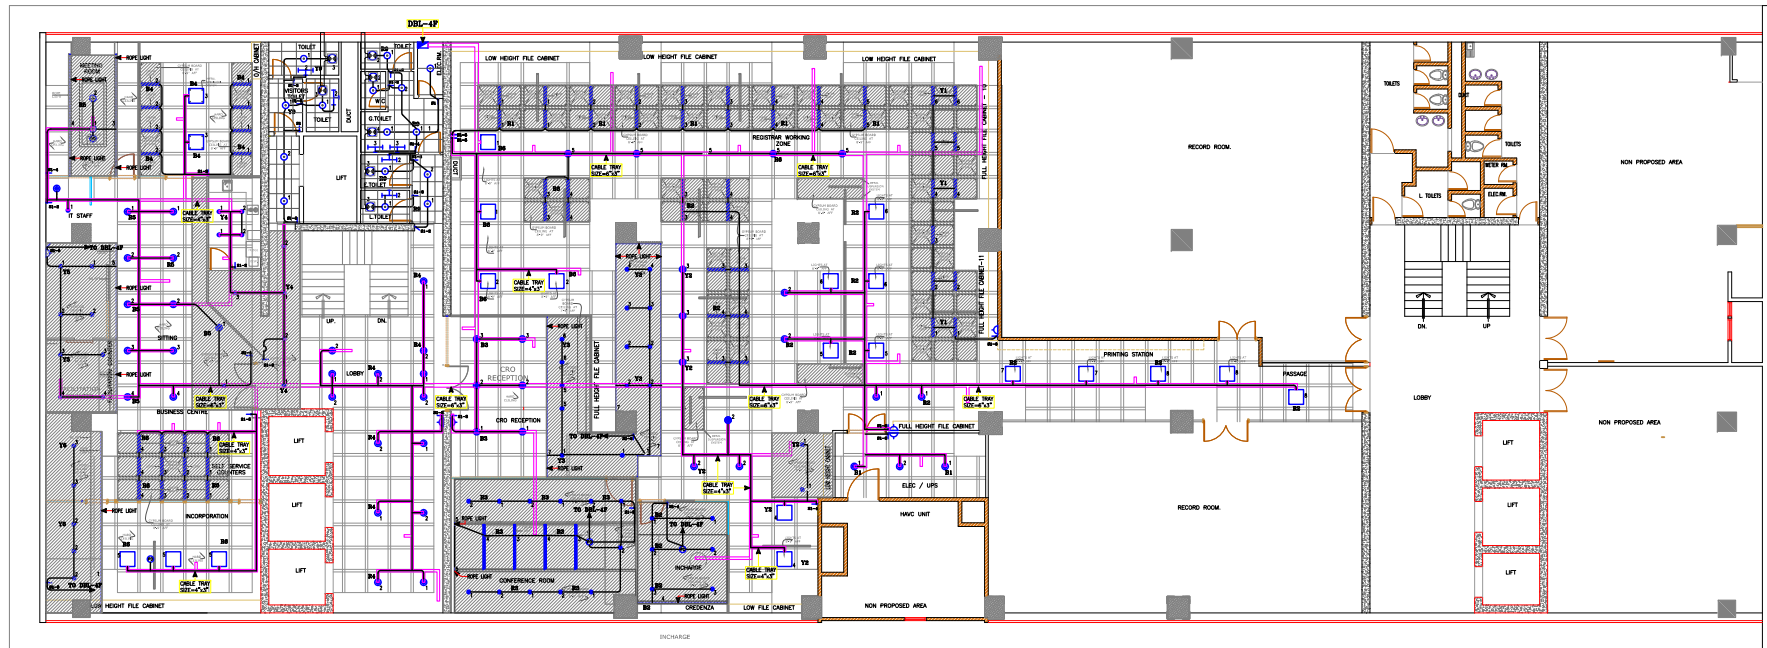


CLIENT:	SECURITIES AND EXCHANGE COMMISSION OF PAKISTAN
PROJECT:	INTERIOR RENOVATION 4TH FLOOR COMPANIES

CONSULTANT:	SOHAIL A. KHAN ASSOCIATES Architecture and Designing House #159, Street 4, Race Course Road, Rawalpindi Tel: 5174329 - 5174098; Fax: 5125075 Email: mail@saka.net.pk
-------------	--

MEP CONSULTANT:	RAAHIM ASSOCIATES MEP ENGINEERS & CONSULTANT FLAT 07, 1F SHERAZ PLAZA, GULBERG II, LHR Ph: 042-35764449, Cell no: 0333-4320990 E-mail: raahimassociates@gmail.com
-----------------	---

DRAWING TITLE:	ILLUMINATION LAYOUT PLAN
----------------	--------------------------


DESIGN BY:	CH.USAMA	DRAWN BY:	M.AKRAM	CHECK BY:	S.Y.B
SCALE:	N.T.S	DATE:	15.06.2020	DWG.NO:	E-04

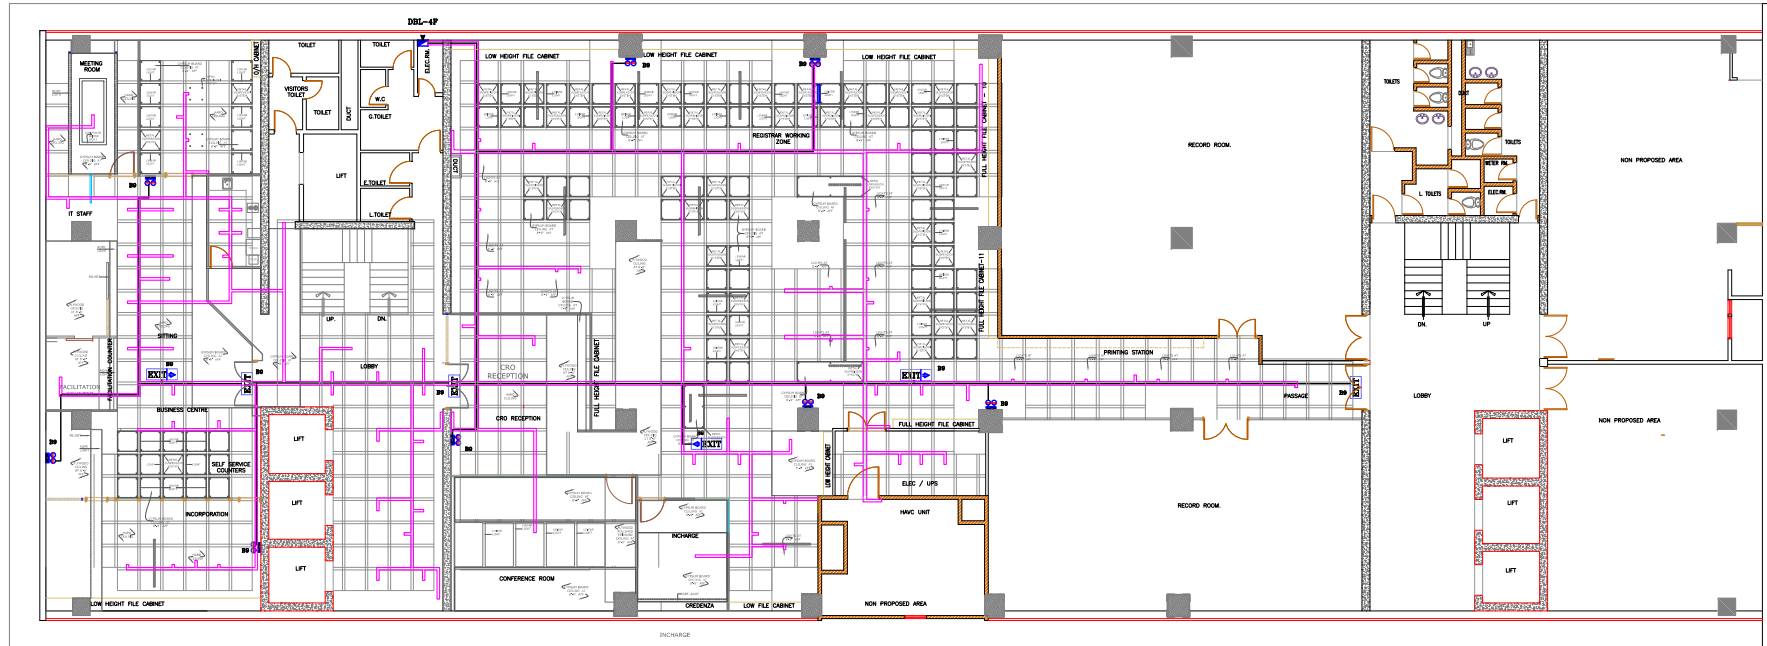

CLIENT:
SECURITIES AND EXCHANGE
COMMISSION OF PAKISTAN

PROJECT:
INTERIOR RENOVATION
4TH FLOOR COMPANIES

 CONSULTANT:
SOHAIL A. KHAN ASSOCIATES
Architecture and Designing
House #159, Street 4, Race Course Road, Rawalpindi
Tel: 5174329 - 5174098; Fax: 5125075
Email: mail@saka.net.pk




MEP CONSULTANT:
RAAHIM ASSOCIATES
MEP ENGINEERS & CONSULTANT
FLAT 07, 1F SHERAZ PLAZA, GULBERG II, LHR
Ph: 042-35764449; Cell no: 0333-4320990
E-mail: raahimassociates@gmail.com



DRAWING TITLE:
**EMERGENCY & EXIT LIGHT
LAYOUT PLAN**

DESIGN BY: CH.USAMA	DRAWN BY: M.AKRAM	CHECK BY: S.Y.B
SCALE: N.T.S	DATE: 15.06.2020	DWG.NO: E-05

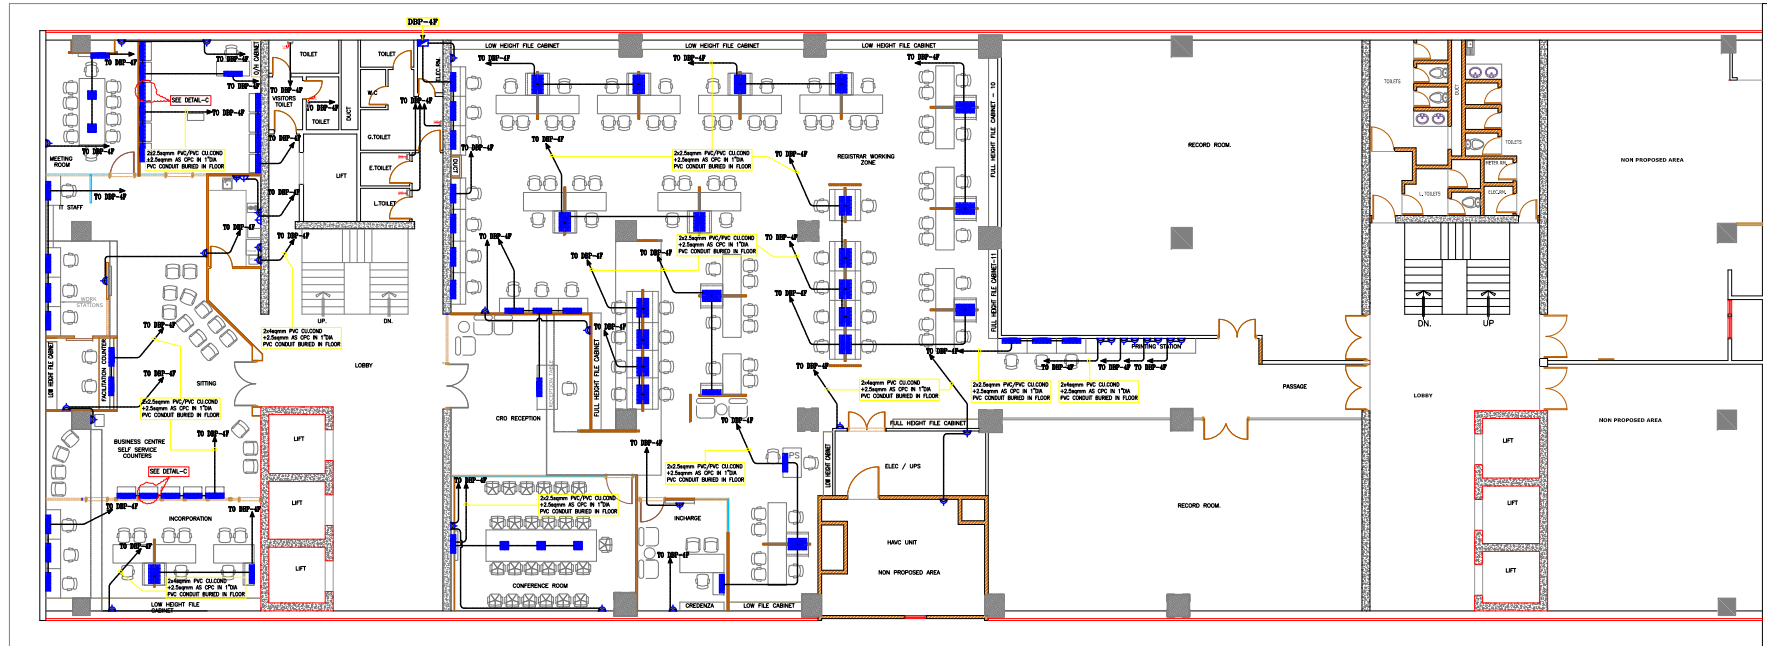

CLIENT:	SECURITIES AND EXCHANGE COMMISSION OF PAKISTAN
PROJECT:	INTERIOR RENOVATION 4TH FLOOR COMPANIES

CONSULTANT:	SOHAIL A. KHAN ASSOCIATES Architecture and Designing House #159, Street 4, Race Course Road, Rawalpindi Tel: 5174329 - 5174098; Fax: 5125075 Email: mail@saka.net.pk
-------------	--

MEP CONSULTANT:	RAAHIM ASSOCIATES MEP ENGINEERS & CONSULTANT FLAT 07, 1F SHERAZ PLAZA, GULBERG II, LHR Ph: 042-35764449, Cell no: 0333-4320990 E-mail: raahimassociates@gmail.com
-----------------	---

DRAWING TITLE:	POWER SOCKETS LAYOUT PLAN ON NORMAL SUPPLY
----------------	---

DESIGN BY:	CH.USAMA	DRAWN BY:	M.AKRAM	CHECK BY:	S.Y.B
SCALE:	N.T.S	DATE:	15.06.2020	DWG.NO:	E-06

