



JOB # :	OF/CON/MAS/002	PROJECT:	SECURITIES & EXCHANGE COMMISSION OF PAKISTAN 2740 SQ FT OFFICE	TITLE:	LAYOUT PLAN	DRAWING NO:	ID.AR.SECP.101	
DESIGN BY:	AR.NAMEER JILANI							
DATE:	03 APR 2023							
CAD BY:	USMAN							
SCALE:	3/16" = 1'-0"							

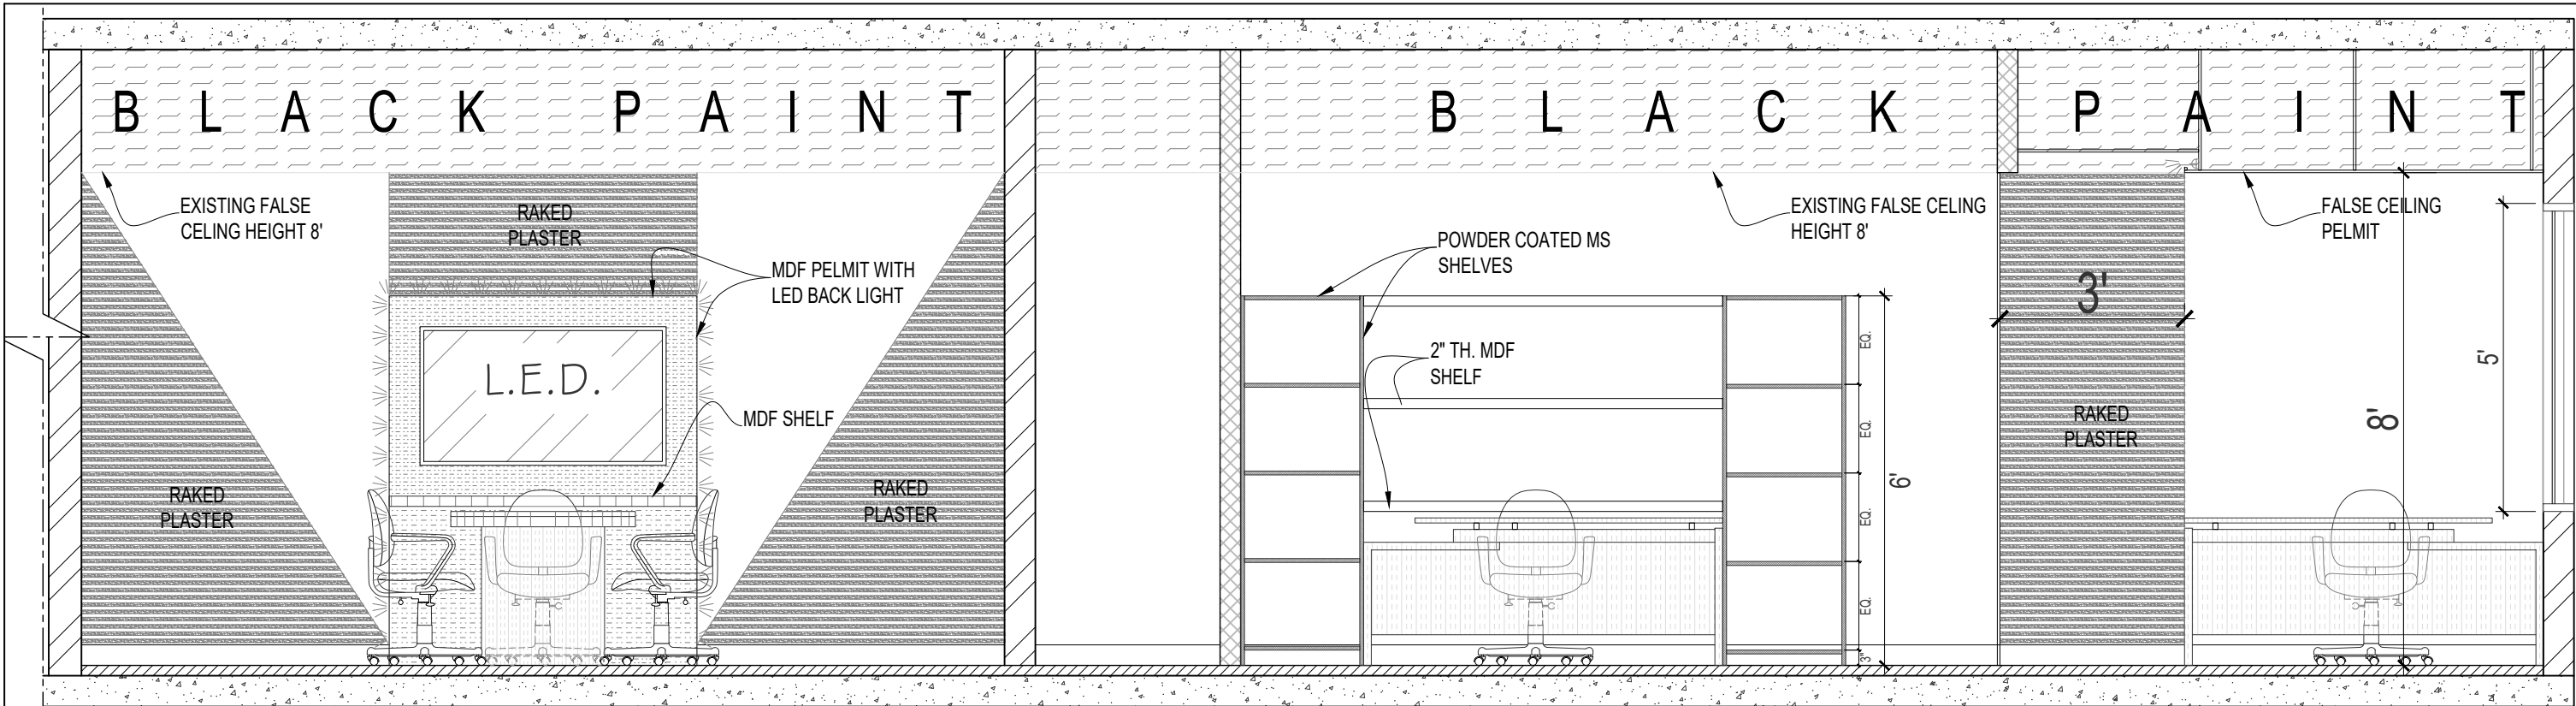


ELEVATION A SCALE: 3/8" = 1'-0"

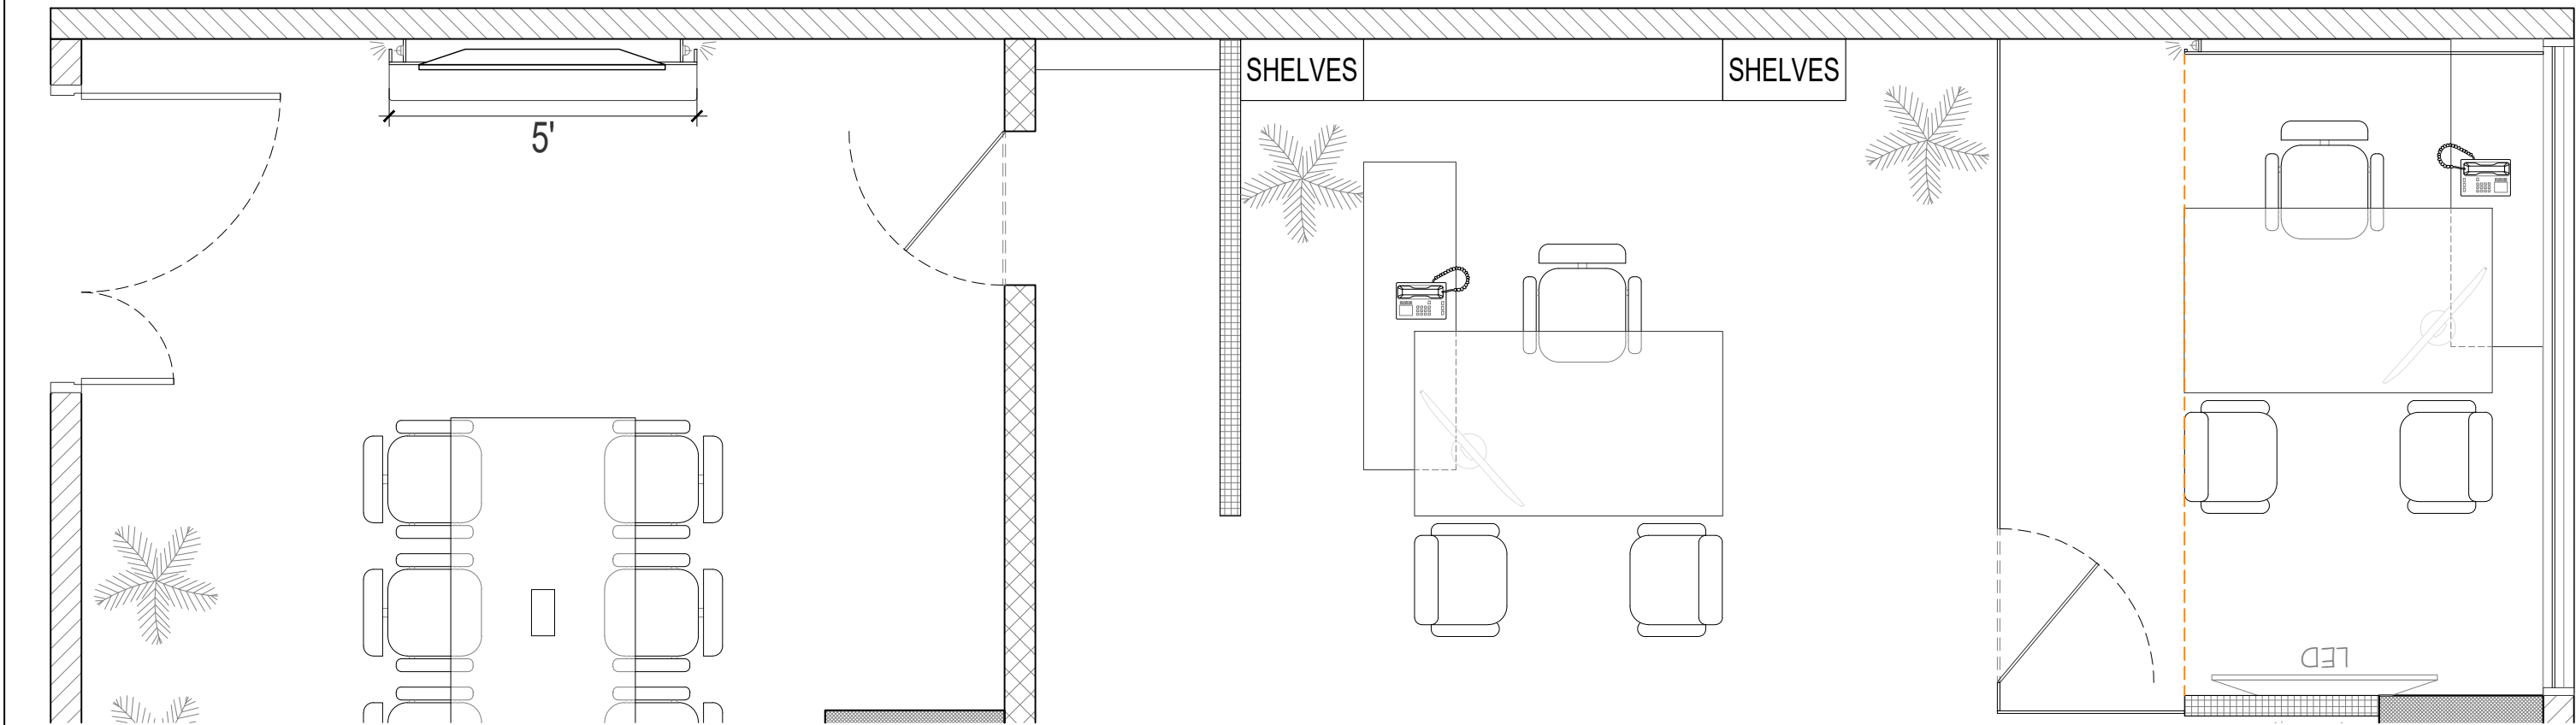


PART PLAN SCALE: 3/8" = 1'-0"

JOB # :	OF/CON/MAS/002	PROJECT:	TITLE:	DRAWING NO:	
DESIGN BY:	AR.NAMEER JILANI	<b>SECURITIES &amp; EXCHANGE COMMISSION OF PAKISTAN</b> 2740 SQ FT OFFICE	<h1>ELEVATION A</h1>	<b>ID.AR.SECP.201</b>	
DATE:	03 APR 2023				
CAD BY:	USMAN				
SCALE:	3/8" = 1'-0"				

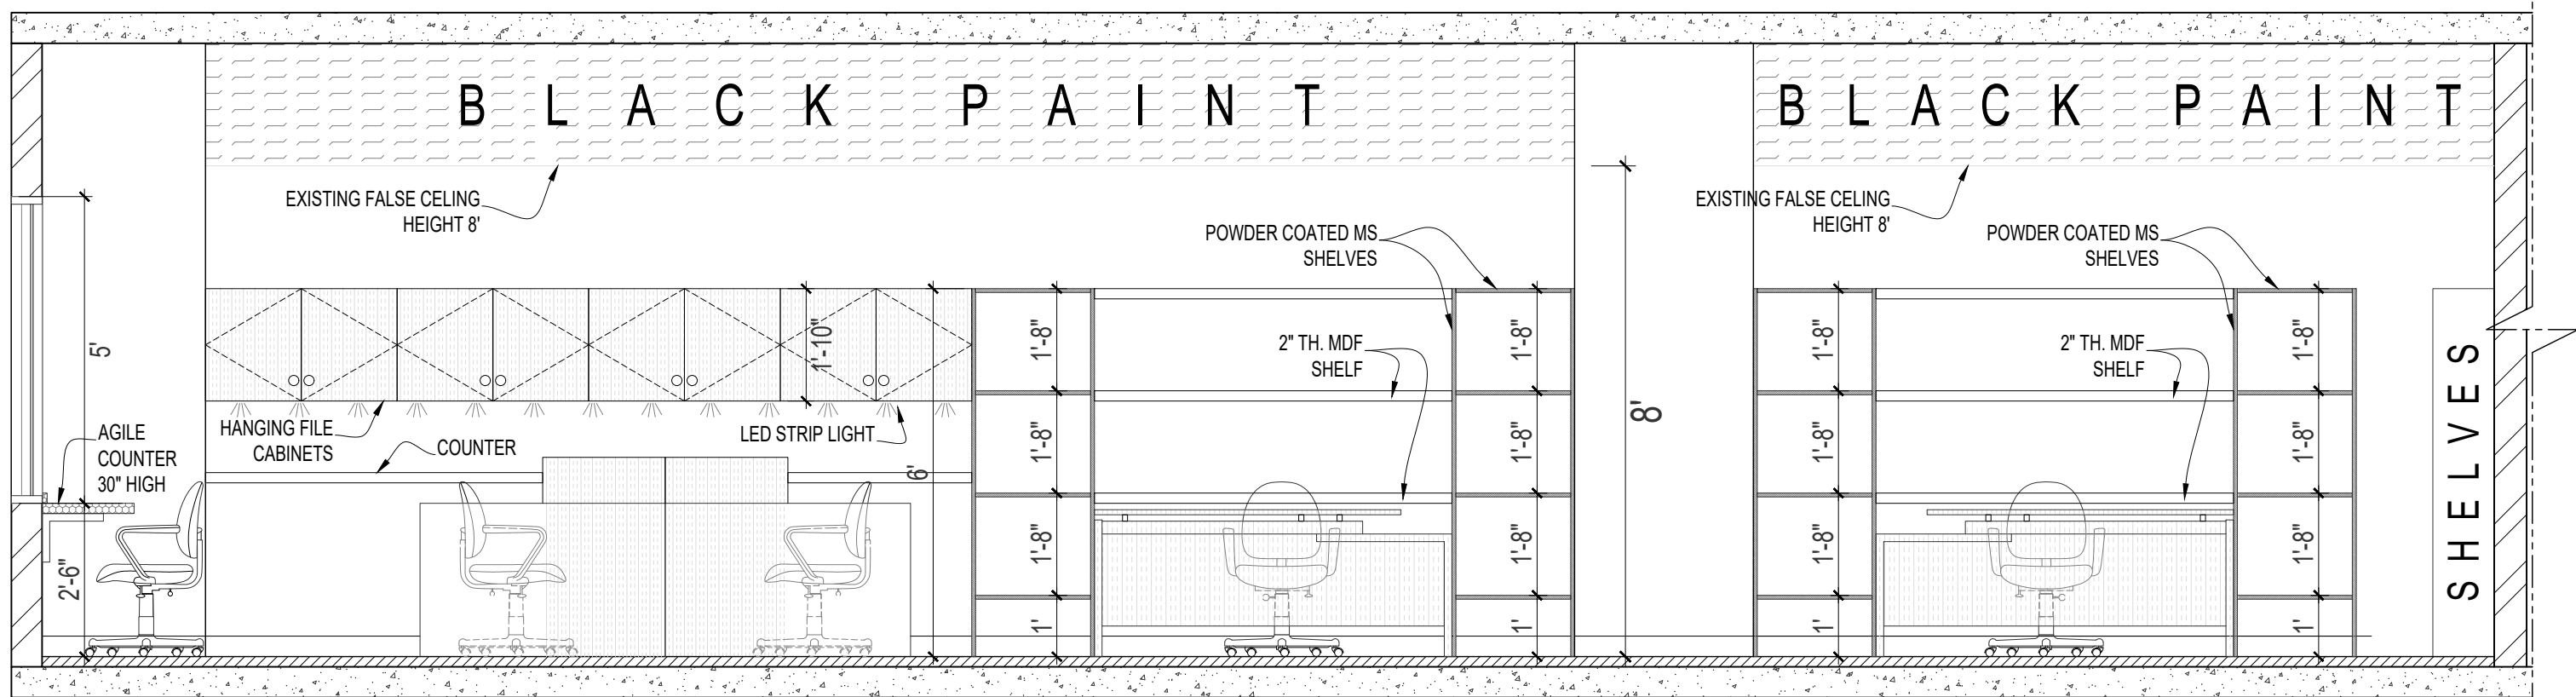

**ELEVATION B**      SCALE: 3/8" = 1'-0"

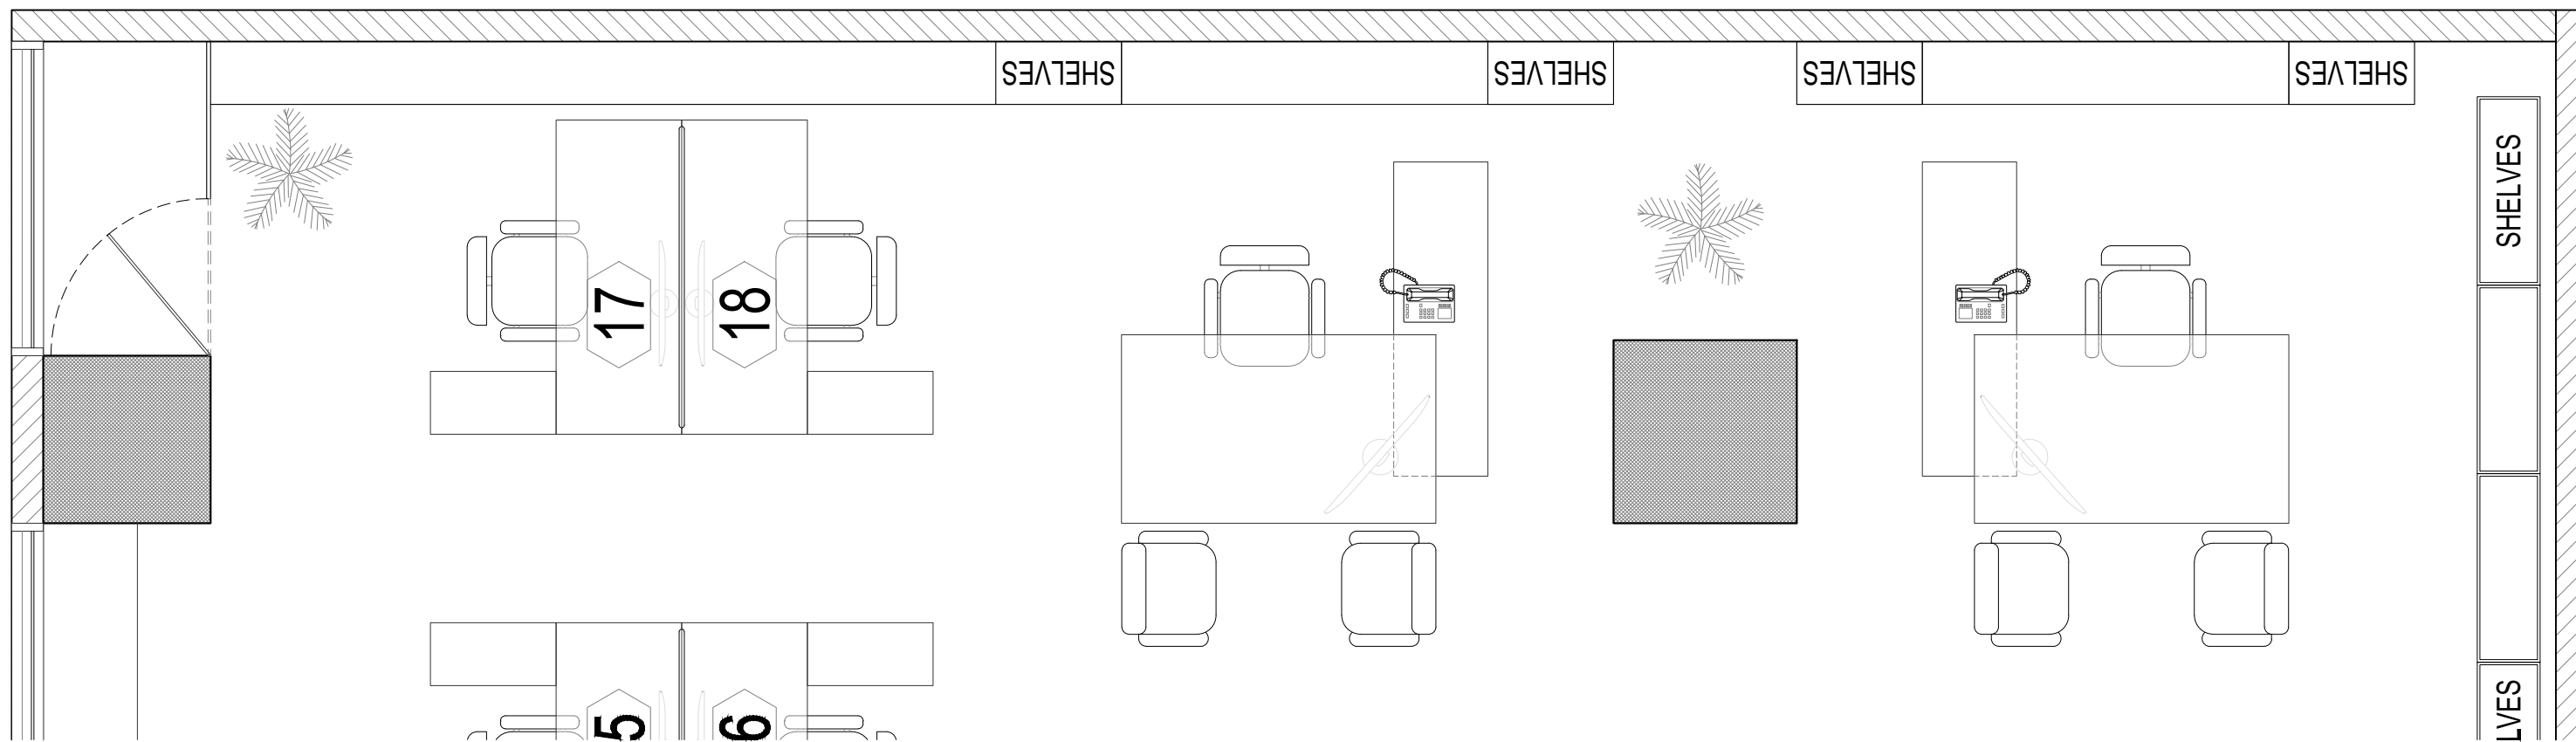

**PART PLAN**      SCALE: 3/8" = 1'-0"

JOB # :	OF/CON/MAS/002
DESIGN BY:	AR.NAMEER JILANI
DATE:	03 APR 2023
CAD BY:	USMAN
SCALE:	3/8" = 1'-0"

PROJECT:  
**SECURITIES & EXCHANGE  
COMMISSION OF PAKISTAN**  
2740 SQ FT OFFICE


TITLE:


**ELEVATION B**



DRAWING NO:






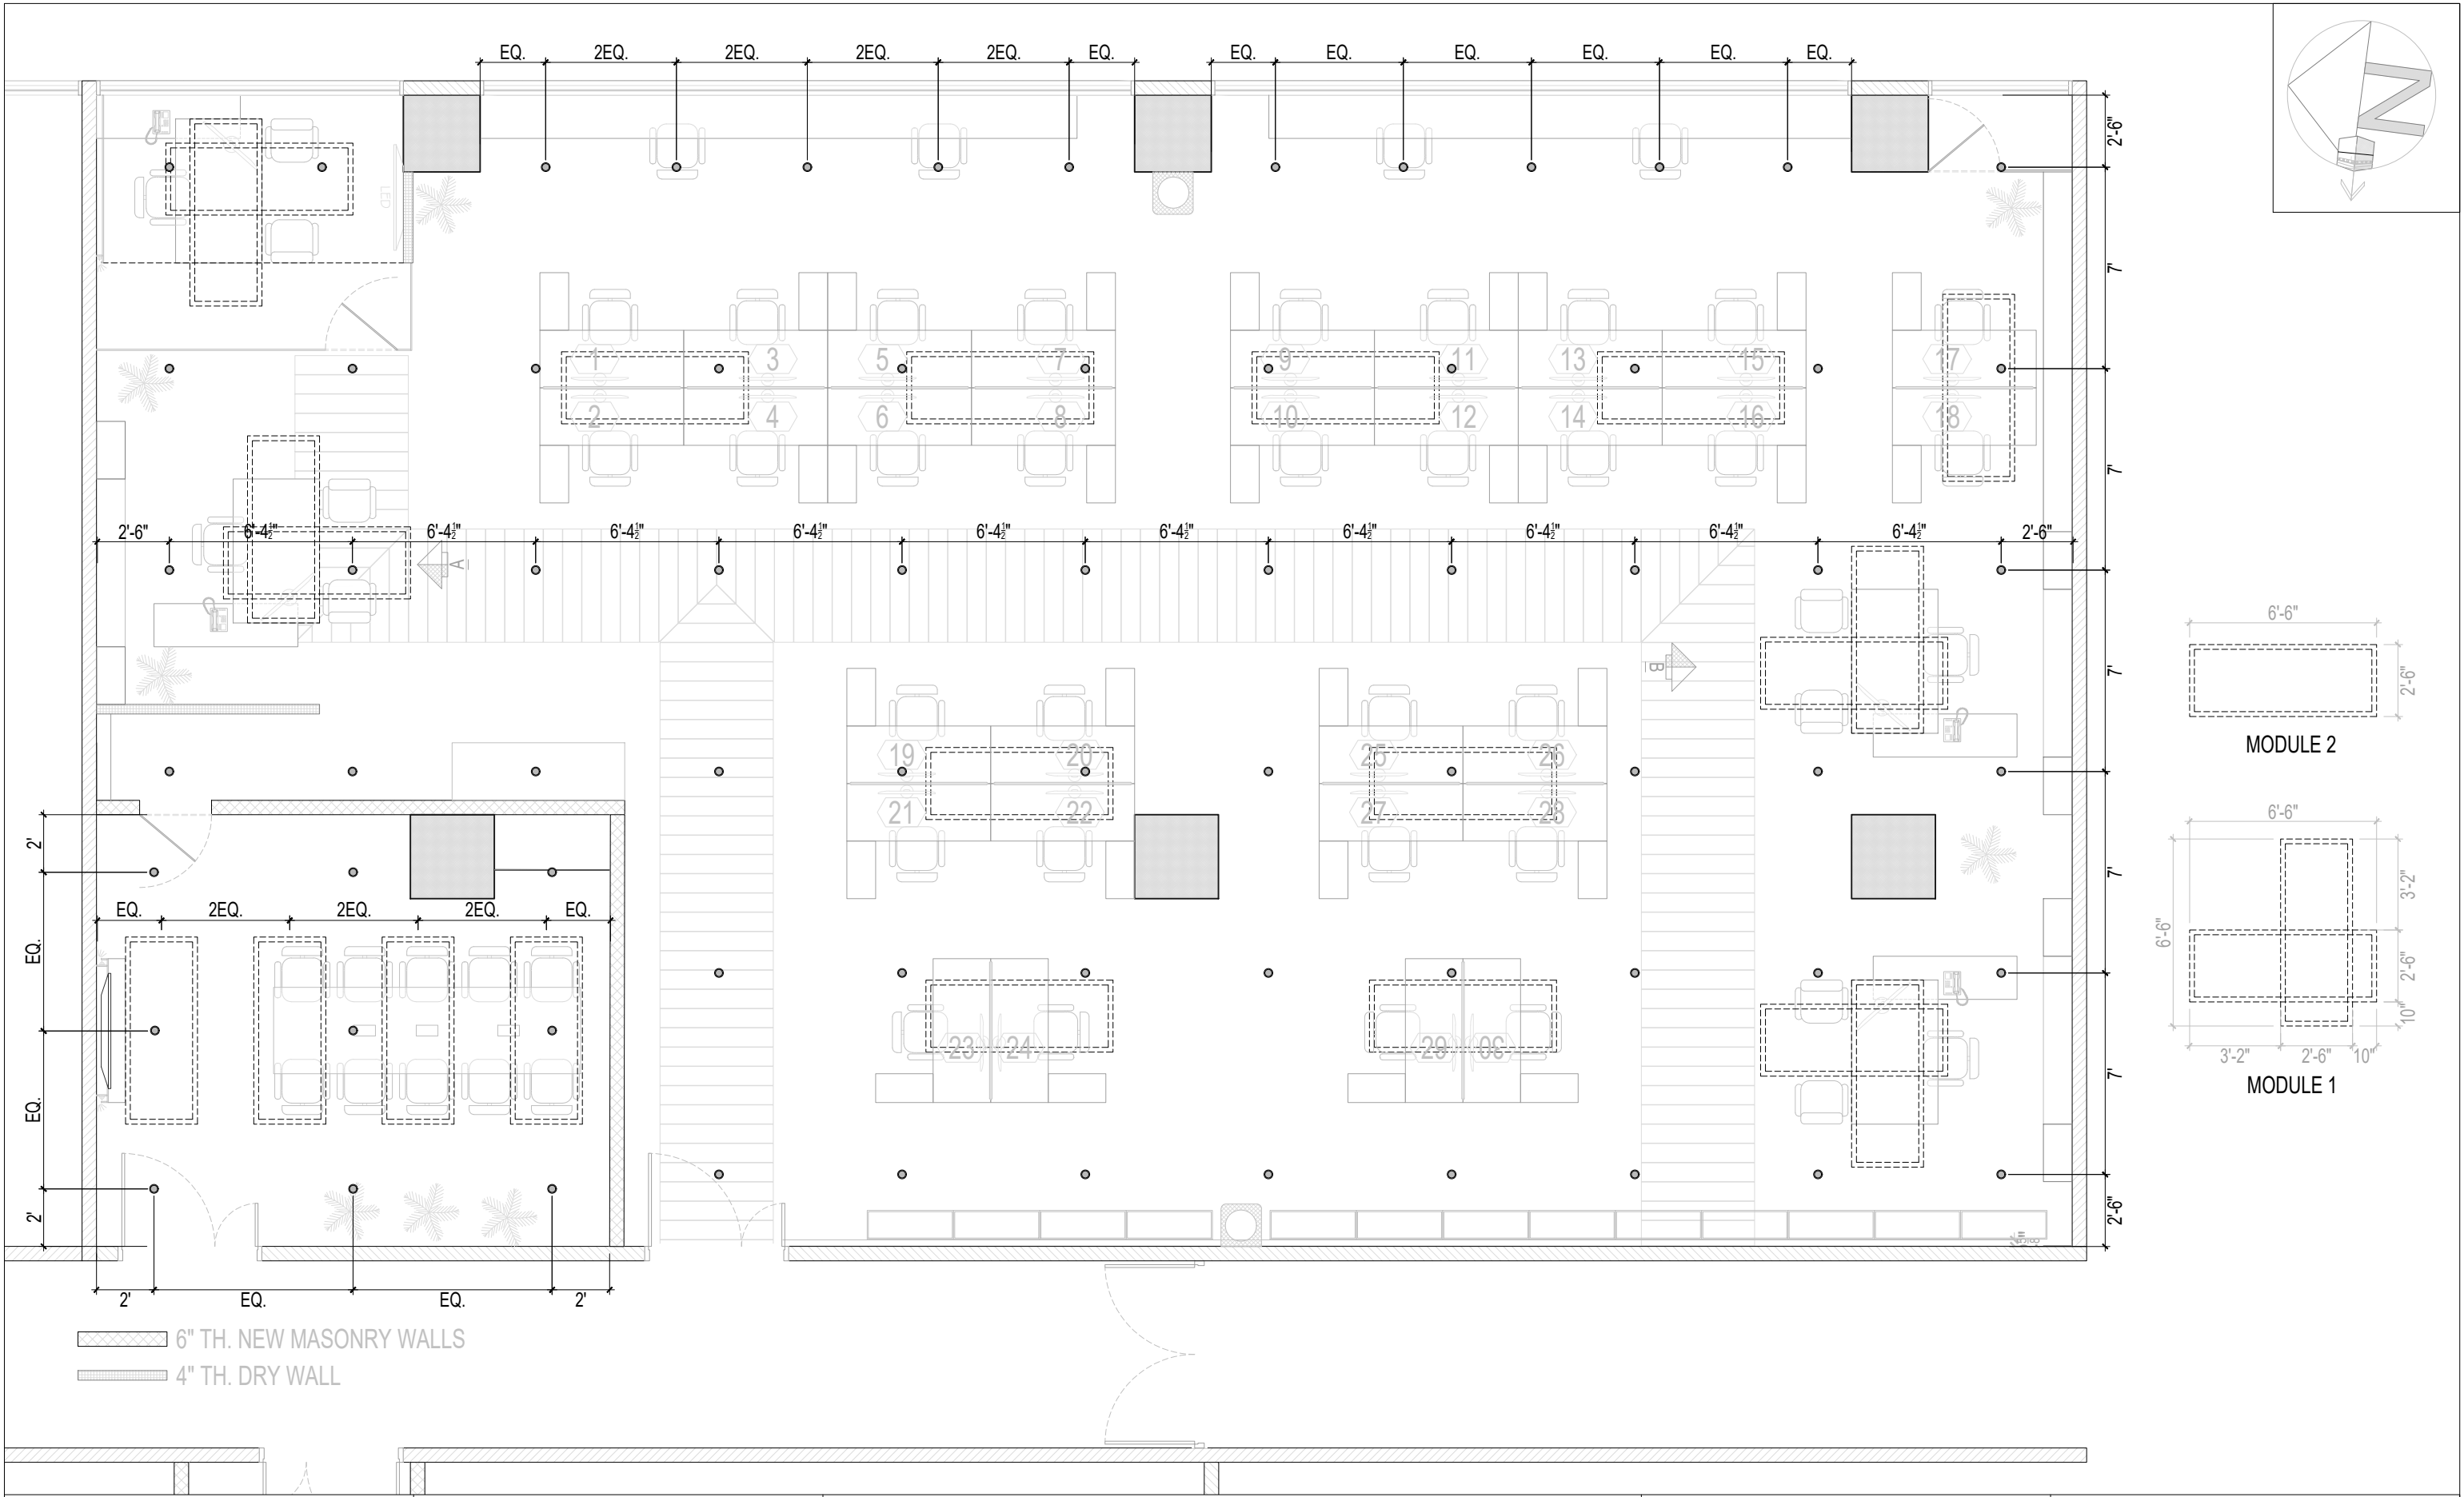

**ID.AR.SECP.202**

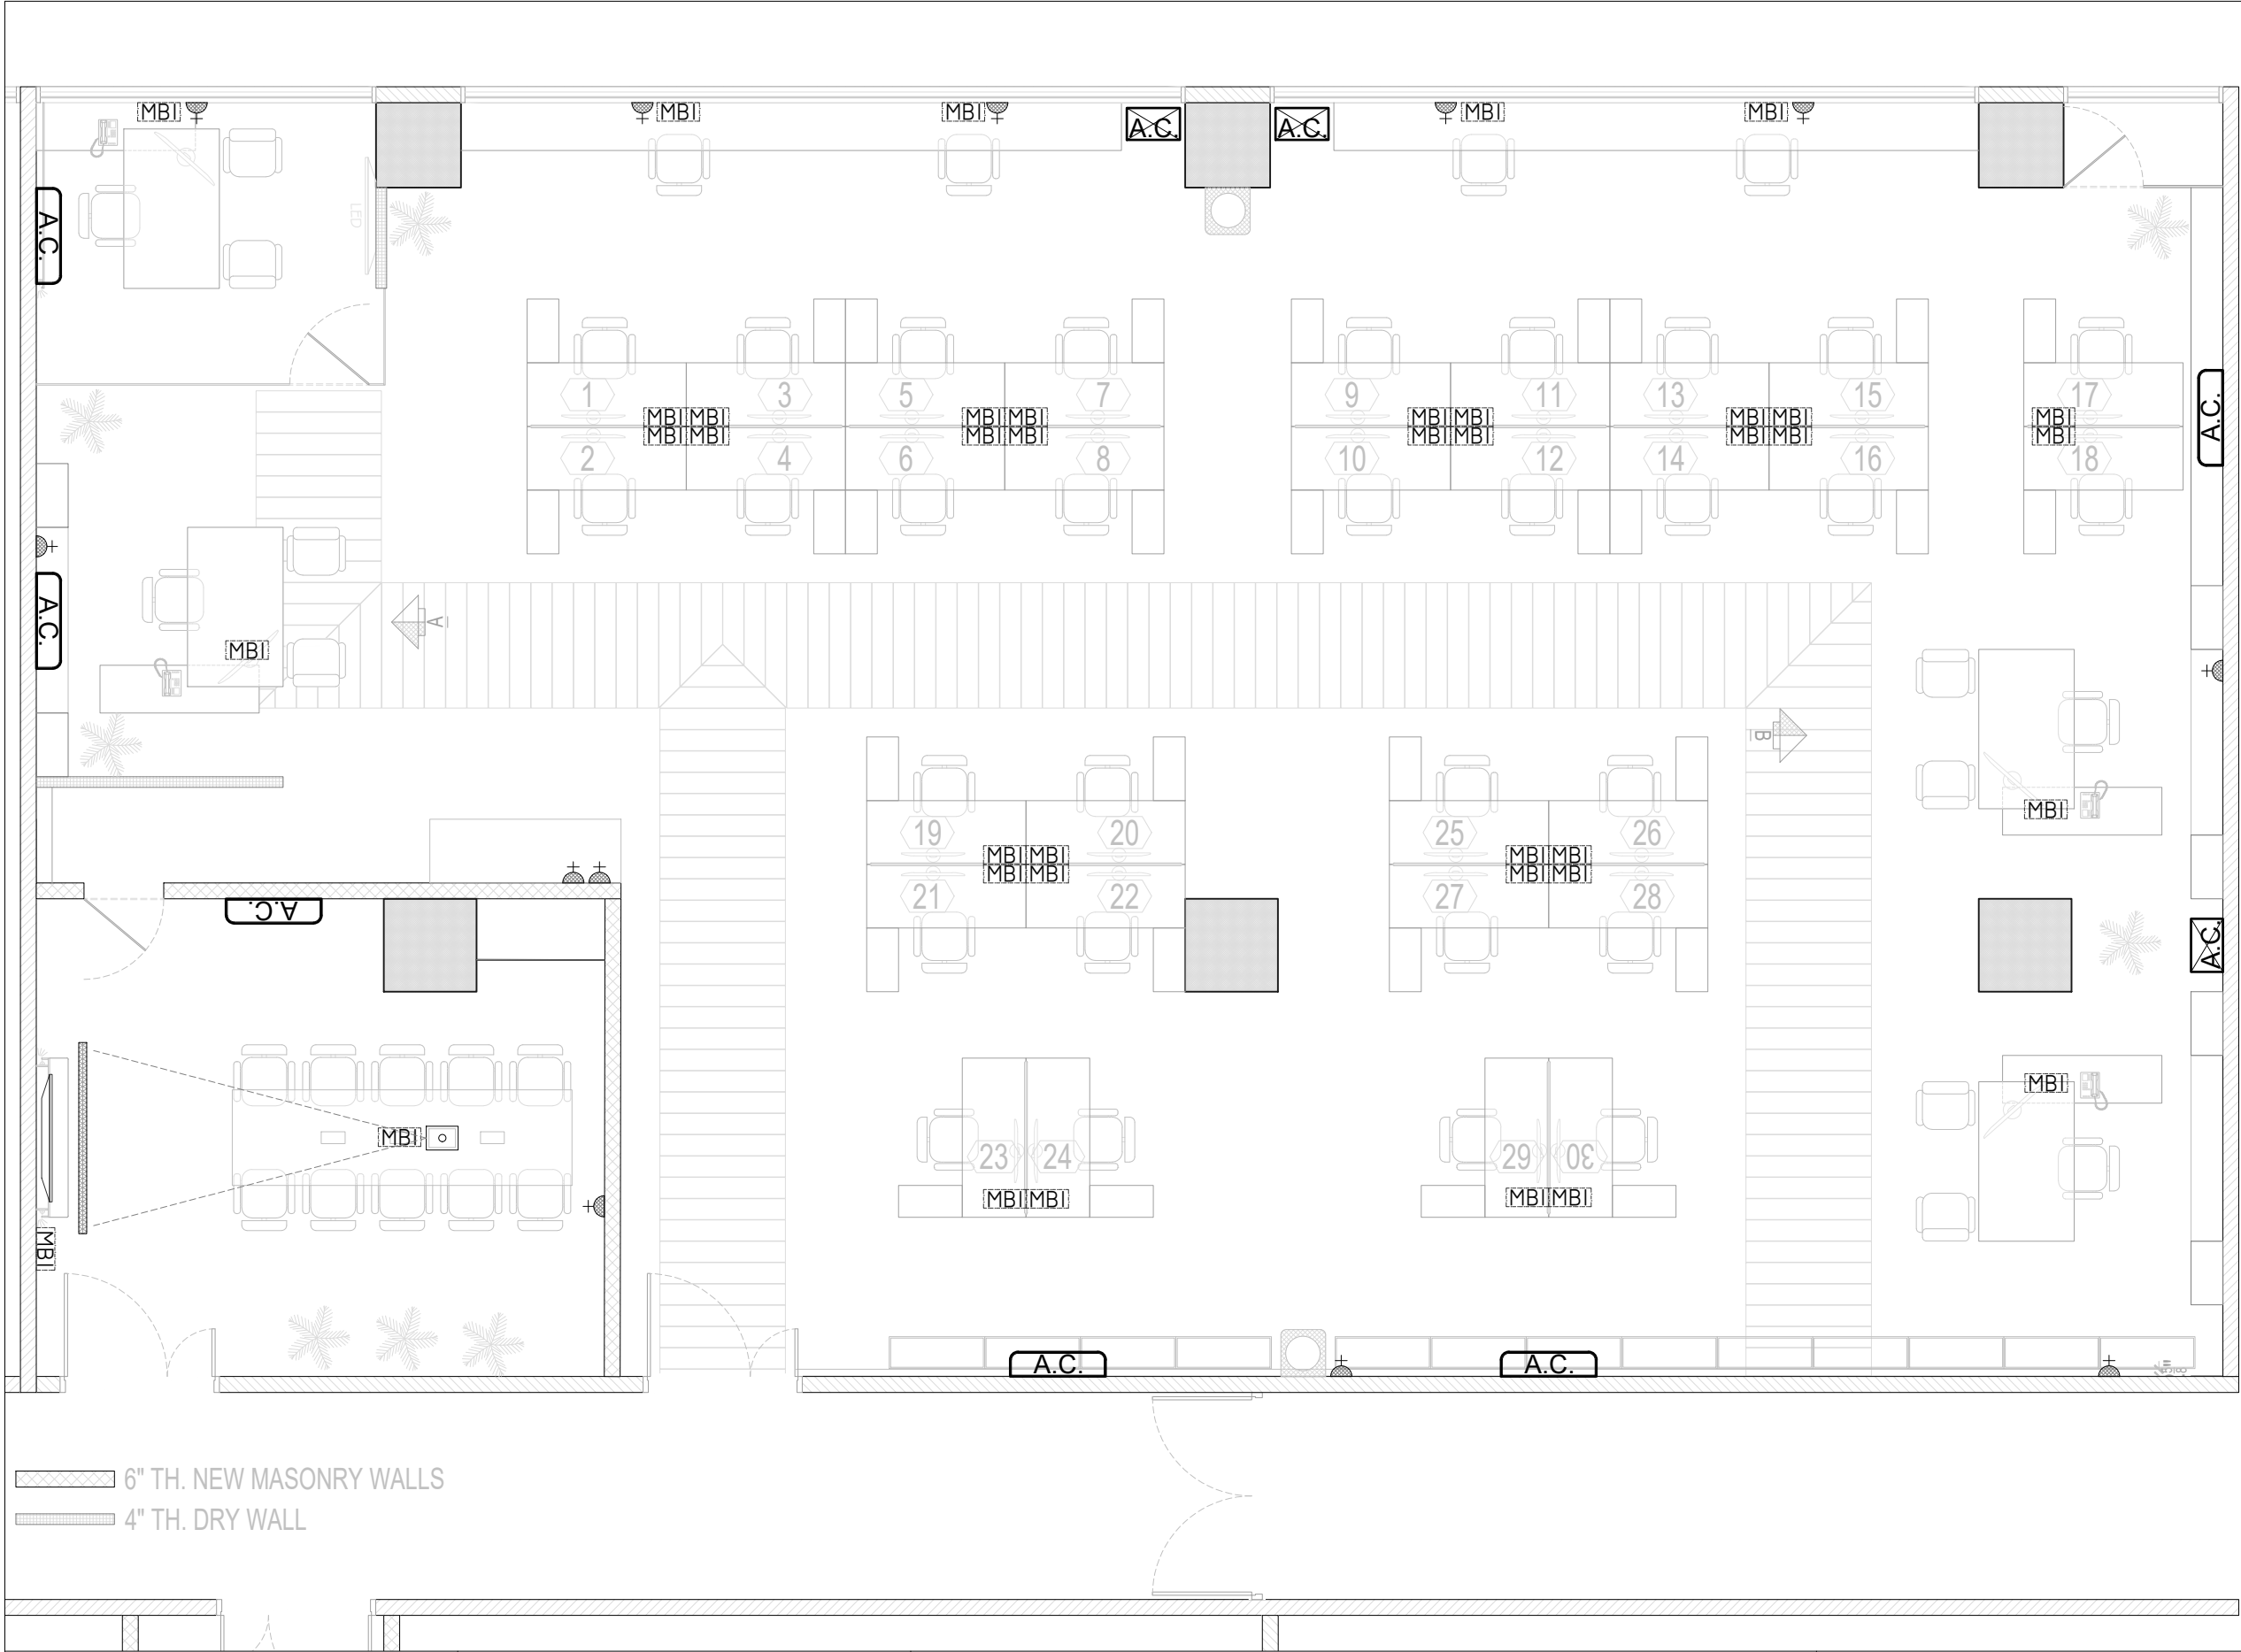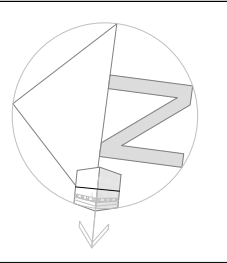

 


JOB # :	OF/CON/MAS/002	PROJECT:	TITLE:	DRAWING NO:	<div><p>MUKHTAR ENTERPRISES STUDIO FOR ARCHITECTURE</p></div>
DESIGN BY:	AR.NAMEER JILANI	<div>SECURITIES &amp; EXCHANGE COMMISSION OF PAKISTAN 2740 SQ FT OFFICE</div> <div>LIGHTING LAYOUT PLAN</div>		ID.AR.SECP.401	
DATE:	03 APR 2023				
CAD BY:	USMAN				
SCALE:	3/16" = 1'-0"				



LEGEND		
SYMBOL	DESCRIPTION	HEIGHT
	INDUSTRIAL SWITCH SOCKET	1'-0" F.F.L.
	SUSPENDED PROJECTOR	7'-0" F.F.L.
	SUSPENDED PROJECTOR SCREEN	CEILING
	AIR CONDITIONER SPLIT UNIT	8'-0" F.F.L.
	AIR CONDITIONER TOWER	FLOOR
	BIOMETRIC ATTENDANCE MACHINE	4'-0" F.F.L.
	MULTI SOCKET BOARD I	FLOOR MOUNTED OR 1' FROM F.F.L.
	1. 1x 13 AMP SSO, LIVE WIRE	
	2. 1x 13 AMP SSO, U.P.S. WIRE	
	3. 1x RJ 45	
	4. 1x CAT 6	
	NOTE: ALL MBI ARE FLOOR MOUNTED EXCEPT MARKED AGAINST THE WALL	

6" TH. NEW MASONRY WALLS  
 4" TH. DRY WALL

JOB # :	OF/CON/MAS/002	PROJECT:	TITLE:	DRAWING NO:	
DESIGN BY:	AR.NAMEER JILANI	SECURITIES & EXCHANGE COMMISSION OF PAKISTAN 2740 SQ FT OFFICE	ELECTRICAL LAYOUT PLAN	ID.AR.SECP.501	
DATE:	03 APR 2023				
CAD BY:	USMAN				
SCALE:	3/16" = 1'-0"				